


PRINCE EDWARD DRIVE
BURIED IRRIGATION PIPE

SEE IRRIGATION PIPING LAYOUT
BY AINLEY GRAHAM

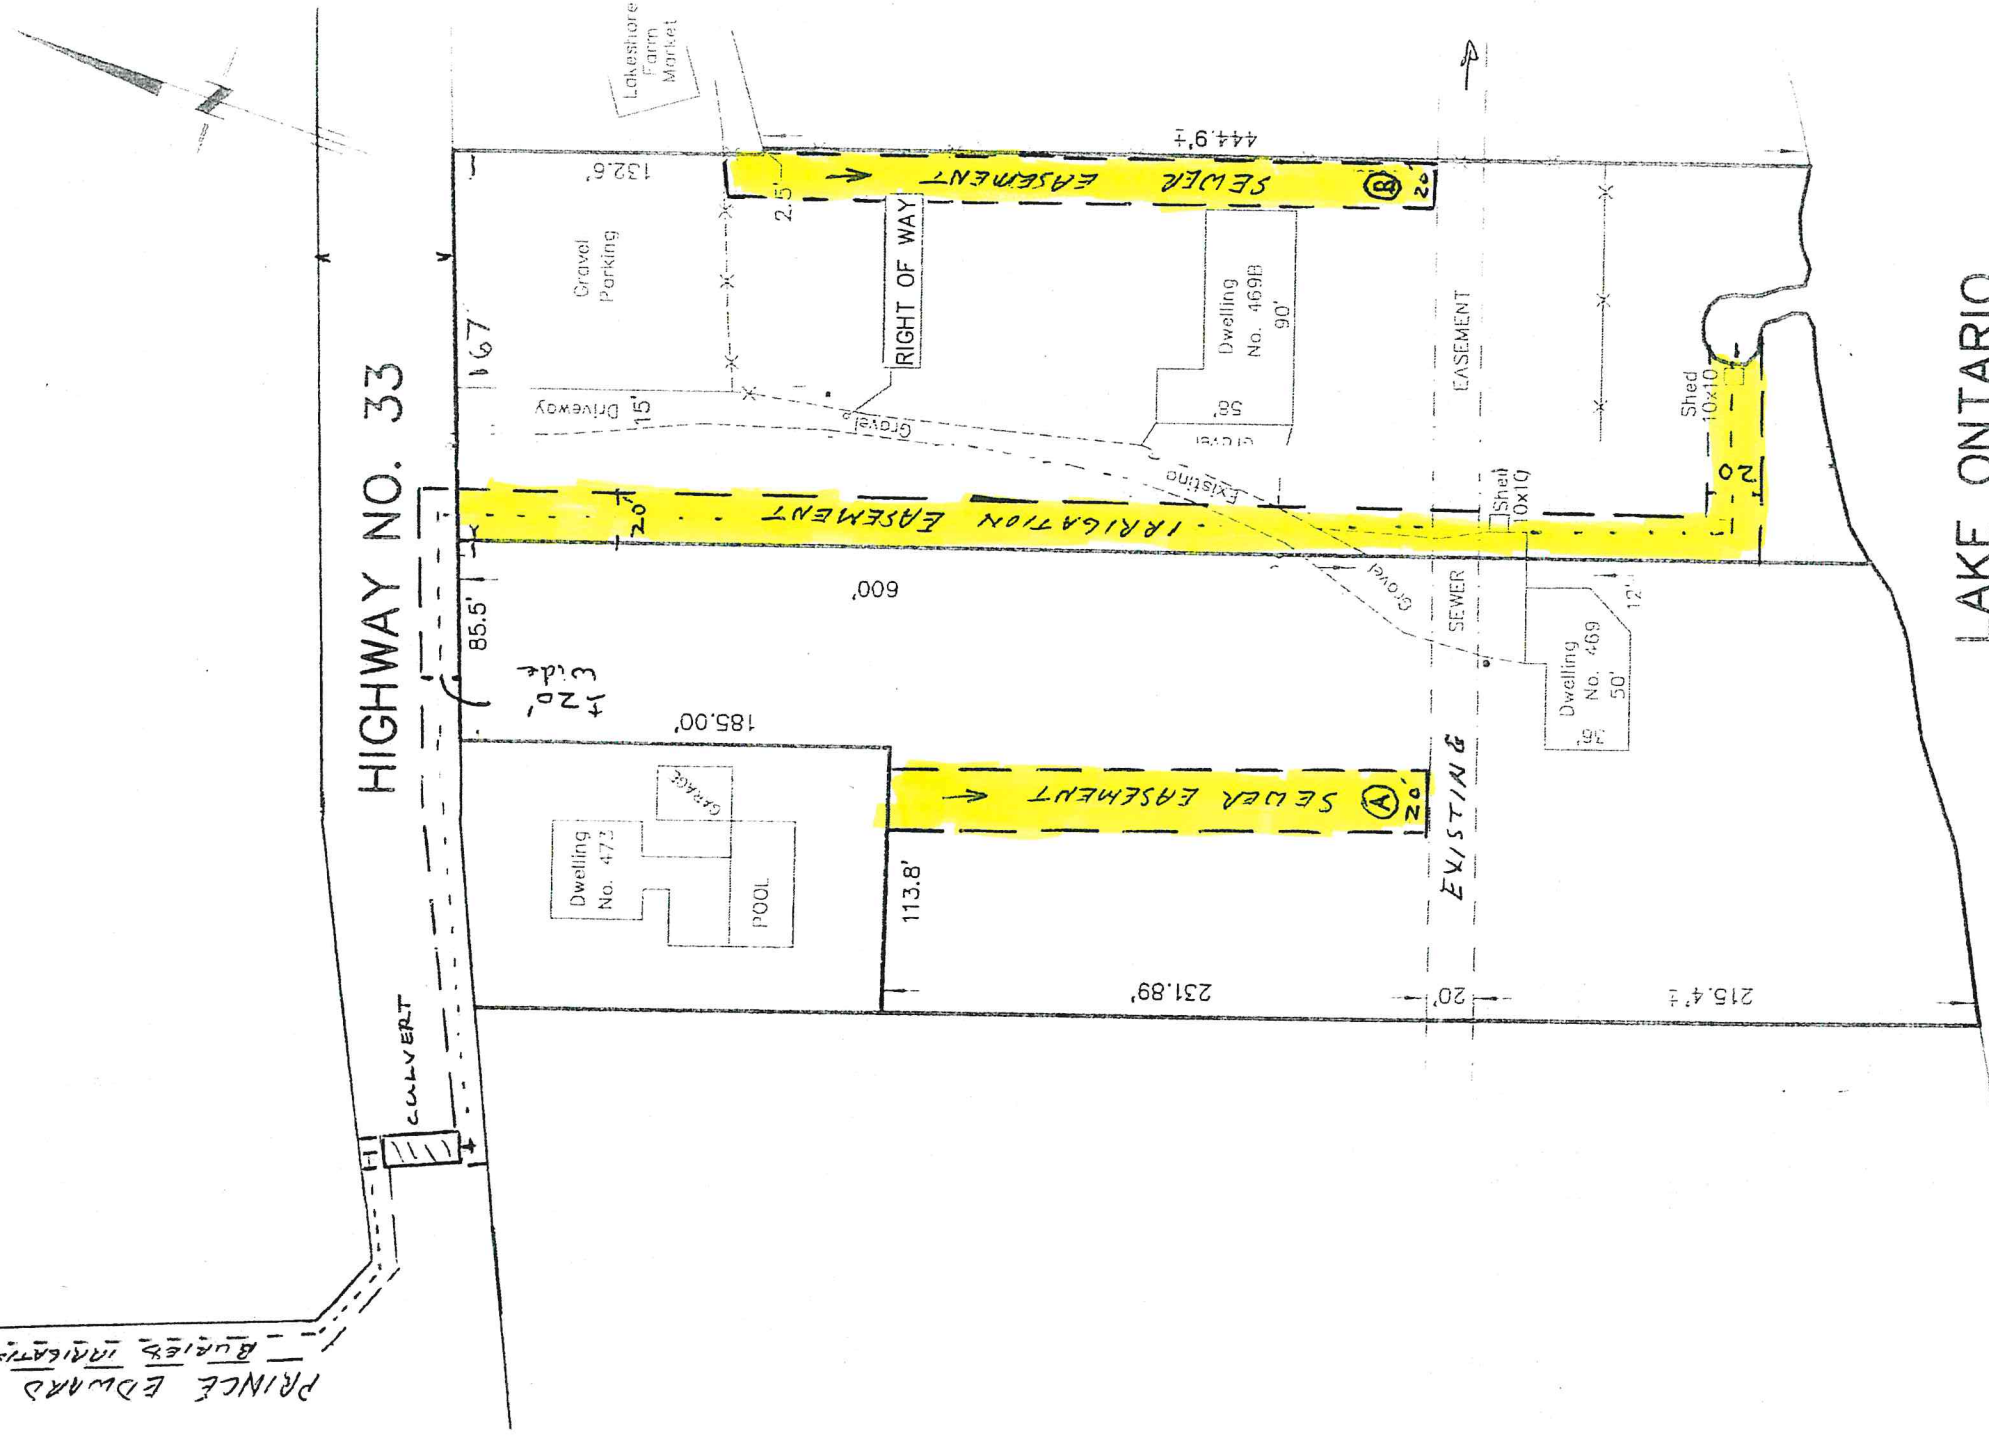

HIGHWAY NO. 33

LAKE ONTARIO

IMPERIAL SCALE 1" = 80'

CAUTION THIS IS NOT A PLAN OF SURVEY
PORTIONS OF THIS SKETCH ARE FROM
COMPILED AND CALCULATED INFORMATION

218 CHURCH STREET
BELLEVILLE, ONTARIO

WATSON

LAND SURVEYORS Ltd.

KBN - JC3
(613) 962 - 9521

August 10, 2020

PROJECT No.