


PRINCE EDWARD DRIVE  
BUKIER IRRIGATION PIPE

SEE IRRIGATION PIPING LAYOUT  
BY AINLEY GRAHAM

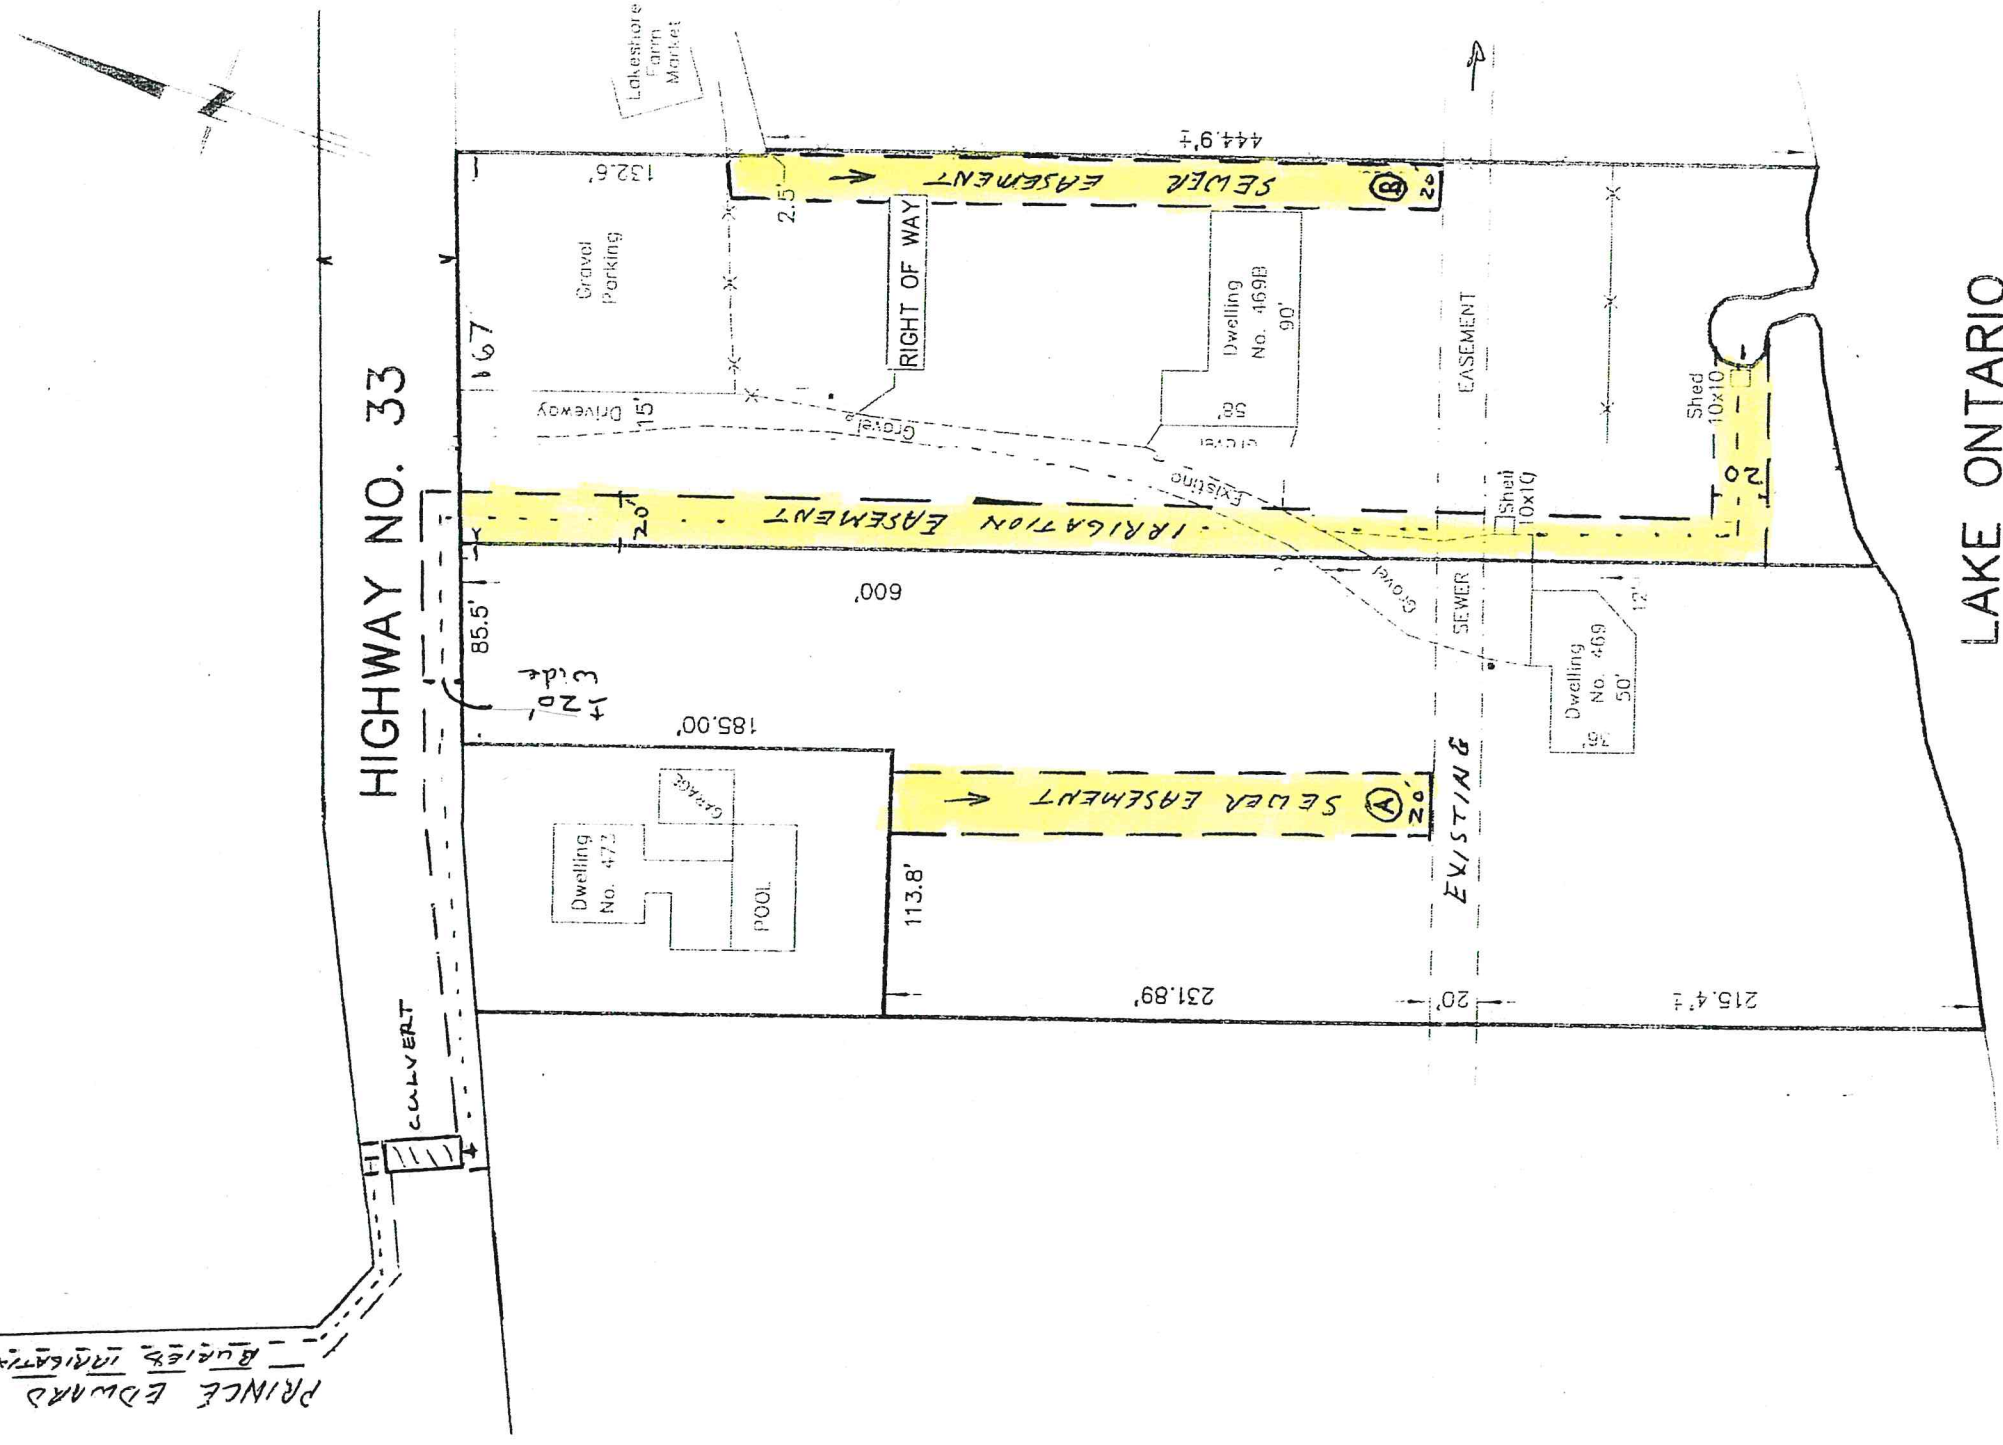

LAKE ONTARIO

IMPERIAL SCALE 1" = 80'  
CAUTION THIS IS NOT A PLAN OF SURVEY  
PORTIONS OF THIS SKETCH ARE FROM  
COMPILED AND CALCULATED INFORMATION

218 CHURCH STREET  
BELLEVILLE, ONTARIO

**WATSON**  
LAND SURVEYORS Ltd.

KBN - 303  
(613) 962 - 9521

August 10 2020 PROJECT No.