


PRINCE EDWARD DRIVE
BURIED IRRIGATION PIPE

SEE IRRIGATION PIPING LAYOUT
BY AINLEY GRAHAM

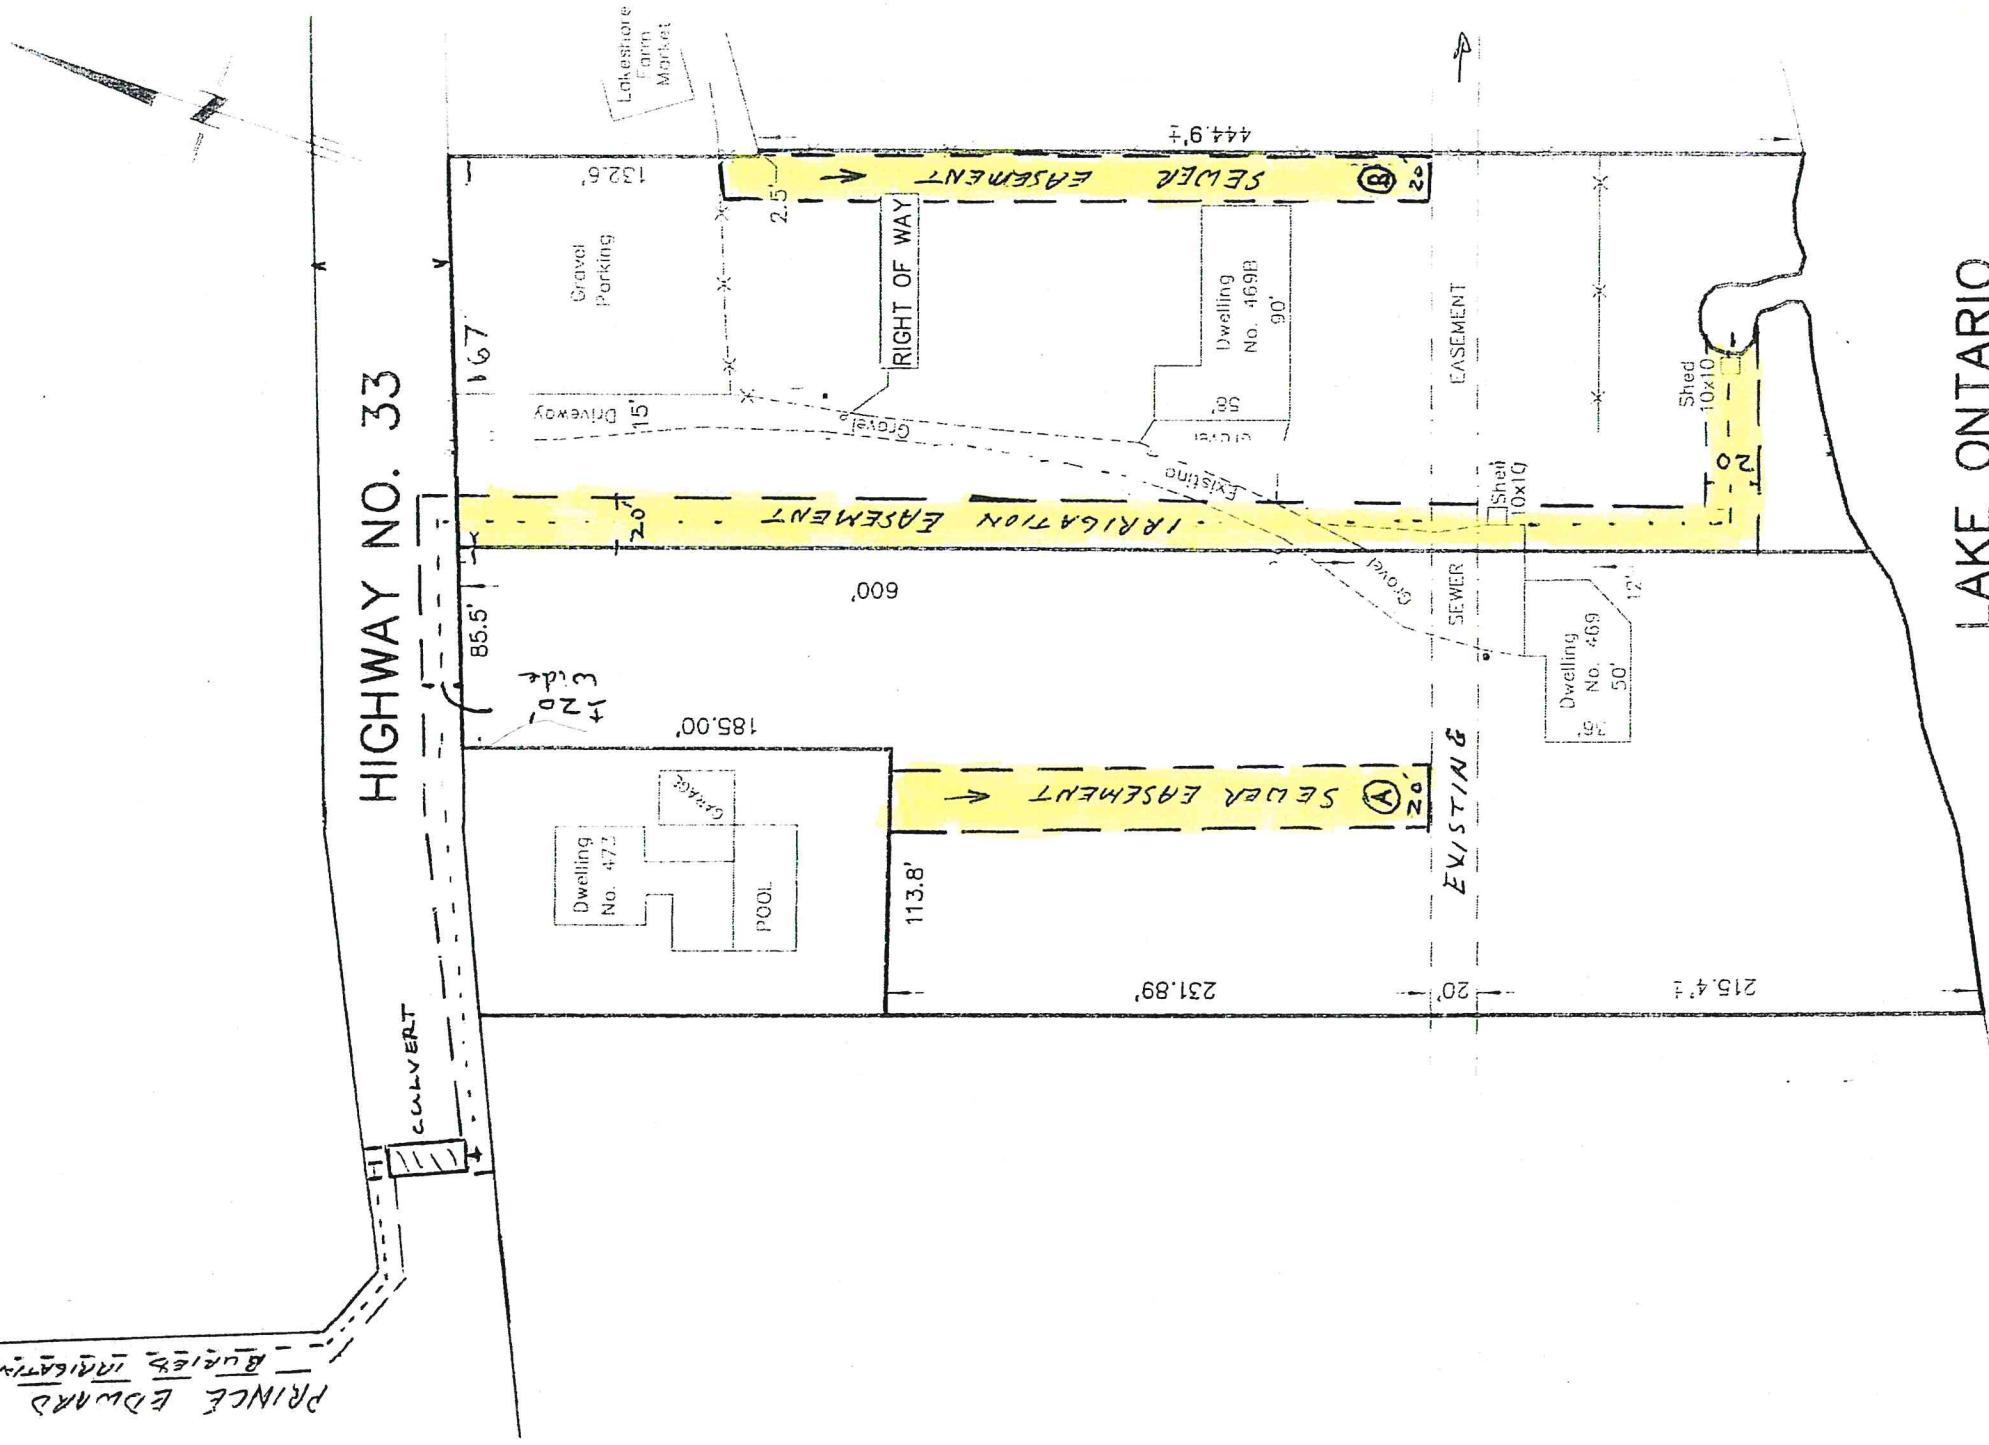

IMPERIAL SCALE 1" = 80'
CAUTION THIS IS NOT A PLAN OF SURVEY
PORTIONS OF THIS SKETCH ARE FROM
COMPILED AND CALCULATED INFORMATION

218 CHURCH STREET
BELLEVILLE, ONTARIO

WATSON
LAND SURVEYORS Ltd.

KBN - 303
(613) 962-9521

August 10, 2020

PROJECT No.