

CAD PLOTTER: Tomf
 FILE PATH: \\S:\Civil\2025\25-575A - Ellicott Realty - 5738 County Road 1\05 Drawings\Ongoing\25-575A - 5738 CR1 - Electrical - Current.dwg
 DATE PLOTTED: 2025 / 08 / 12 @ 03:06 PM
 PLOT SCALE: 1:1
 BORDER SIZE: ISO A1 (841mm x 594mm)

LUMINAIRE SCHEDULE						
SYMBOL	QTY	DESCRIPTION	TAG	LLF	LUMINAIRE LUMENS	LUMINAIRE WATTS
	11	ANP LIGHTING DECORATIVE ROUND PENDANT, LED, TYPE-2 3000K CCT, WITH PHOTOCELL, BRONZE PART NUMBER SWBFT18E030LDST230KPC51	A	0.900	3019	30
	4	ANP LIGHTING DECORATIVE ROUND PENDANT, LED, TYPE-2 3000K CCT, WITH PHOTOCELL, BRONZE PART NUMBER SWBFT18E030LDST430KPC51	C	0.900	3171	30

* C/W POLE ANP LIGHTING BD6SQS(XX).7-SBDC6FW-99 (REFER TO INDIVIDUAL MOUNTING HEIGHTS FOR XX, EQUAL TO 16 OR 18)
 C/W ARM ANP LIGHTING PA1000 3-1-6-S-99

** EQUIVALENT LUMINAIRES ARE ACCEPTABLE PROVIDED THEY MEET ALL TECHNICAL SPECIFICATIONS OF SPECIFIED UNITS.
 EQUIVALENTS FOR EXTERIOR LIGHTING SHALL REQUIRE THE SUBMISSION OF IES FILES AND A POINT-BY-POINT PHOTOMETRIC ANALYSIS OF THE ENTIRE SITE INDICATING ILLUMINATION LEVELS.

LIGHTING SYMBOLS

LIGHTS ARE SHOWN ON LIGHTING PLANS WITH TYPE (A,C) AND MOUNTING HEIGHT (M.H.)

ELECTRICAL DRAWING LIST	
DWG NO.	DESCRIPTION
E-000	LEGENDS & SCHEDULES
E-001	SITE PLAN & KEY PLAN
E-002	LIGHTING PLAN PHOTOMETRICS
E-003	LIGHTING PLAN PHOTOMETRICS
E-004	LIGHTING PLAN PHOTOMETRICS



LUMINAIRE/POST DETAIL

- NOTES:
- ALL WORK SHALL BE IN ACCORDANCE WITH RELEVANT CODES AND GUIDELINES.
 - ALL DRAWINGS AND ADDENDA ARE TO BE READ AS, AND IN CONJUNCTION WITH THE SPECIFICATIONS.
 - ALL EQUIPMENT SHALL BE INSTALLED AS SPECIFIED OR APPROVED EQUIVALENT.
 - CONTRACTOR MUST CHECK AND VERIFY ALL DIMENSIONS BEFORE PROCEEDING WITH WORK AND BE RESPONSIBLE FOR SAME.
 - CONTRACTOR MUST REPORT ANY DISCREPANCIES TO ENGINEER FOR RESOLUTION BEFORE COMMENCING THE WORK.
 - ANY CHANGES MUST BE APPROVED BY THE ENGINEER.

- A A DETAIL NO.
B B DRAWING NO. - WHERE DETAILED

REVISION	DESCRIPTION	DATE
03	RE-ISSUED FOR SITE PLAN APPROVAL	25/08/08
02	RE-ISSUED FOR SITE PLAN APPROVAL	25/01/14
01	ISSUED FOR SITE PLAN APPROVAL	24/12/12

NORTH

STAMP

PROJECT
 5738 COUNTY ROAD 1,
 LAKESIDE COTTAGES

CONSECON, ON

AZZORYPA GP. INC.
 PRICE EDWARD COUNTY, ON

DRAWING TITLE
 LEGENDS & SCHEDULES

DESIGNED BY
 S. LANE

DRAWN BY
 T. FUNARI

REVIEWED BY
 S. LANE

APPROVED BY
 S. LANE


PROJECT DATE
 2024/10/06 (YYYY/MM/DD)

PROJECT #
 24-5-6273

DRAWING #
 E-000


DRAWING SCALE (ISO A1)
 HOR: AS SHOWN
 VER: AS SHOWN

CAD PLOTTER: TomF
 FILE PATH: \\S:\Civil\2025\25-575A - Ellicott Realty - 5738 County Road 1\05 Drawings\Ongoing\25-575A - 5738 CR1 - Electrical - Current.dwg
 DATE PLOTTED: 2025 / 08 / 12 @ 03:06 PM
 PLOT SCALE: 1:1
 BORDER SIZE: ISO A1 (841mm x 594mm)

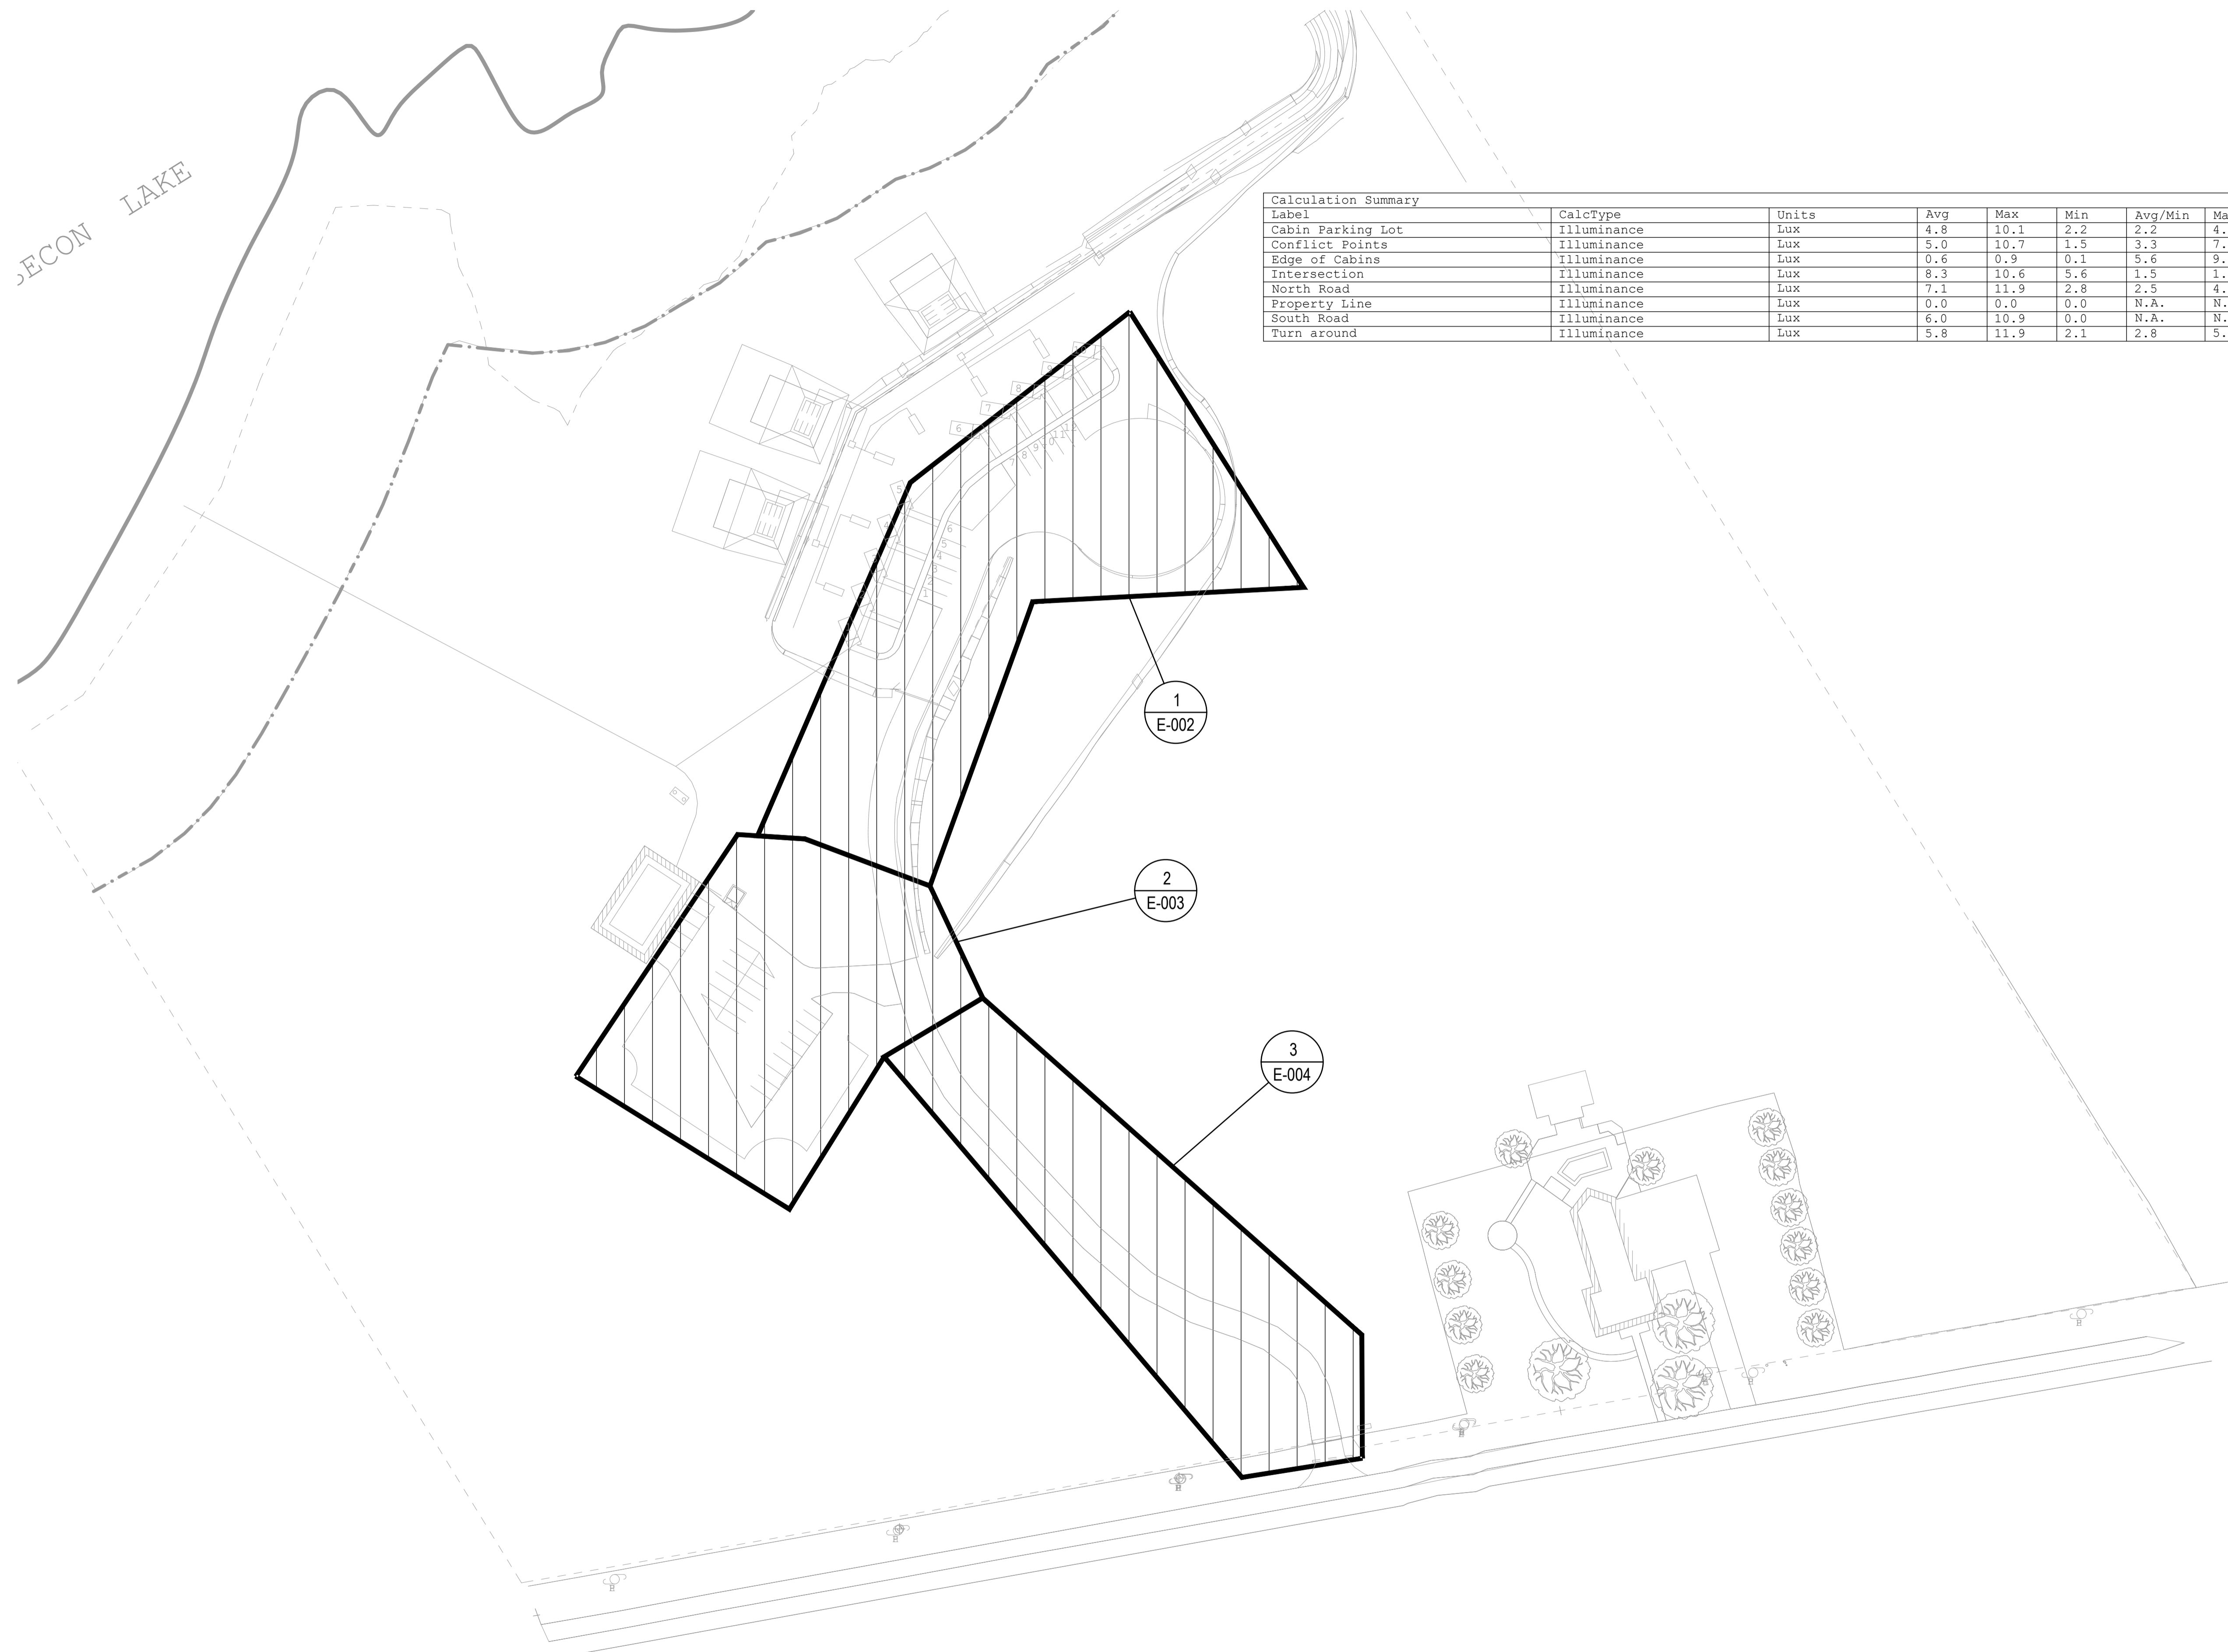

Label	CalcType	Units	Avg	Max	Min	Avg/Min	Max/Min
Cabin Parking Lot	Illuminance	Lux	4.8	10.1	2.2	2.2	4.6
Conflict Points	Illuminance	Lux	5.0	10.7	1.5	3.3	7.1
Edge of Cabins	Illuminance	Lux	0.6	0.9	0.1	5.6	9.0
Intersection	Illuminance	Lux	8.3	10.6	5.6	1.5	1.9
North Road	Illuminance	Lux	7.1	11.9	2.8	2.5	4.3
Property Line	Illuminance	Lux	0.0	0.0	0.0	N.A.	N.A.
South Road	Illuminance	Lux	6.0	10.9	0.0	N.A.	N.A.
Turn around	Illuminance	Lux	5.8	11.9	2.1	2.8	5.7

1 SITE PLAN AND KEY PLAN
E-001 SCALE: 1:750



GREER GALLOWAY
 a division of Jp2g Consultants Inc.
 1620 WALLBRIDGE LOYALIST ROAD
 BELLEVILLE, ONTARIO, K8N 4Z5
 PHONE: 613-966-3068
 FAX: 613-966-3087

NOTES:

- ALL WORK SHALL BE IN ACCORDANCE WITH RELEVANT CODES AND GUIDELINES.
- ALL DRAWINGS AND ADDENDA ARE TO BE READ AS, AND IN CONJUNCTION WITH THE SPECIFICATIONS.
- ALL EQUIPMENT SHALL BE INSTALLED AS SPECIFIED OR APPROVED EQUIVALENT.
- CONTRACTOR MUST CHECK AND VERIFY ALL DIMENSIONS BEFORE PROCEEDING WITH WORK AND BE RESPONSIBLE FOR SAME.
- CONTRACTOR MUST REPORT ANY DISCREPANCIES TO ENGINEER FOR RESOLUTION BEFORE COMMENCING THE WORK.
- ANY CHANGES MUST BE APPROVED BY THE ENGINEER.

A


A DETAIL NO.

B


B DRAWING NO. - WHERE DETAILED

REVISION	DESCRIPTION	DATE
03	RE-ISSUED FOR SITE PLAN APPROVAL	25/08/08
02	RE-ISSUED FOR SITE PLAN APPROVAL	25/01/14
01	ISSUED FOR SITE PLAN APPROVAL	24/12/12

NORTH

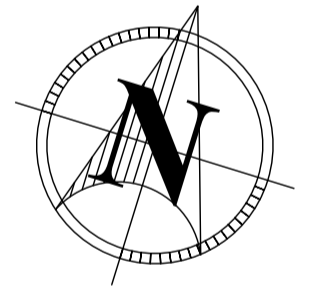

STAMP



PROJECT

5738 COUNTY ROAD 1,
LAKESIDE COTTAGES

CONSECON, ON

AZZORYPA GP. INC.
PRICE EDWARD COUNTY, ON

DRAWING TITLE

SITE PLAN & KEY PLAN
FOR PHOTOMETRIC
PLANS

DESIGNED BY

S. LANE

DRAWN BY

T. FUNARI

REVIEWED BY

S. LANE

APPROVED BY

S. LANE

PROJECT DATE

2024/10/06 (YYYY/MM/DD)

PROJECT #

24-5-6273

DRAWING #

E-001


DRAWING SCALE (ISO A1)

HOR: AS SHOWN
VER: AS SHOWN

CAD PLOTTER: TomF
 FILE PATH: \\S:\Civil\2025\25-575A - Elliott Realty - 5738 County Road 1\05 Drawings\Ongoing\25-575A - 5738 CR1 - Electrical - Current.dwg
 DATE PLOTTED: 2025 / 08 / 12 @ 03:06 PM
 BORDER SIZE: ISO A1 (841mm x 594mm)
 PLOT SCALE: 1:1



- NOTES:
1. ALL WORK SHALL BE IN ACCORDANCE WITH RELEVANT CODES AND GUIDELINES.
 2. ALL DRAWINGS AND ADDENDA ARE TO BE READ AS, AND IN CONJUNCTION WITH THE SPECIFICATIONS.
 3. ALL EQUIPMENT SHALL BE INSTALLED AS SPECIFIED OR APPROVED EQUIVALENT.
 4. CONTRACTOR MUST CHECK AND VERIFY ALL DIMENSIONS BEFORE PROCEEDING WITH WORK AND BE RESPONSIBLE FOR SAME.
 5. CONTRACTOR MUST REPORT ANY DISCREPANCIES TO ENGINEER FOR RESOLUTION BEFORE COMMENCING THE WORK.
 6. ANY CHANGES MUST BE APPROVED BY THE ENGINEER.

- A A DETAIL NO.
 B B DRAWING NO. - WHERE DETAILED

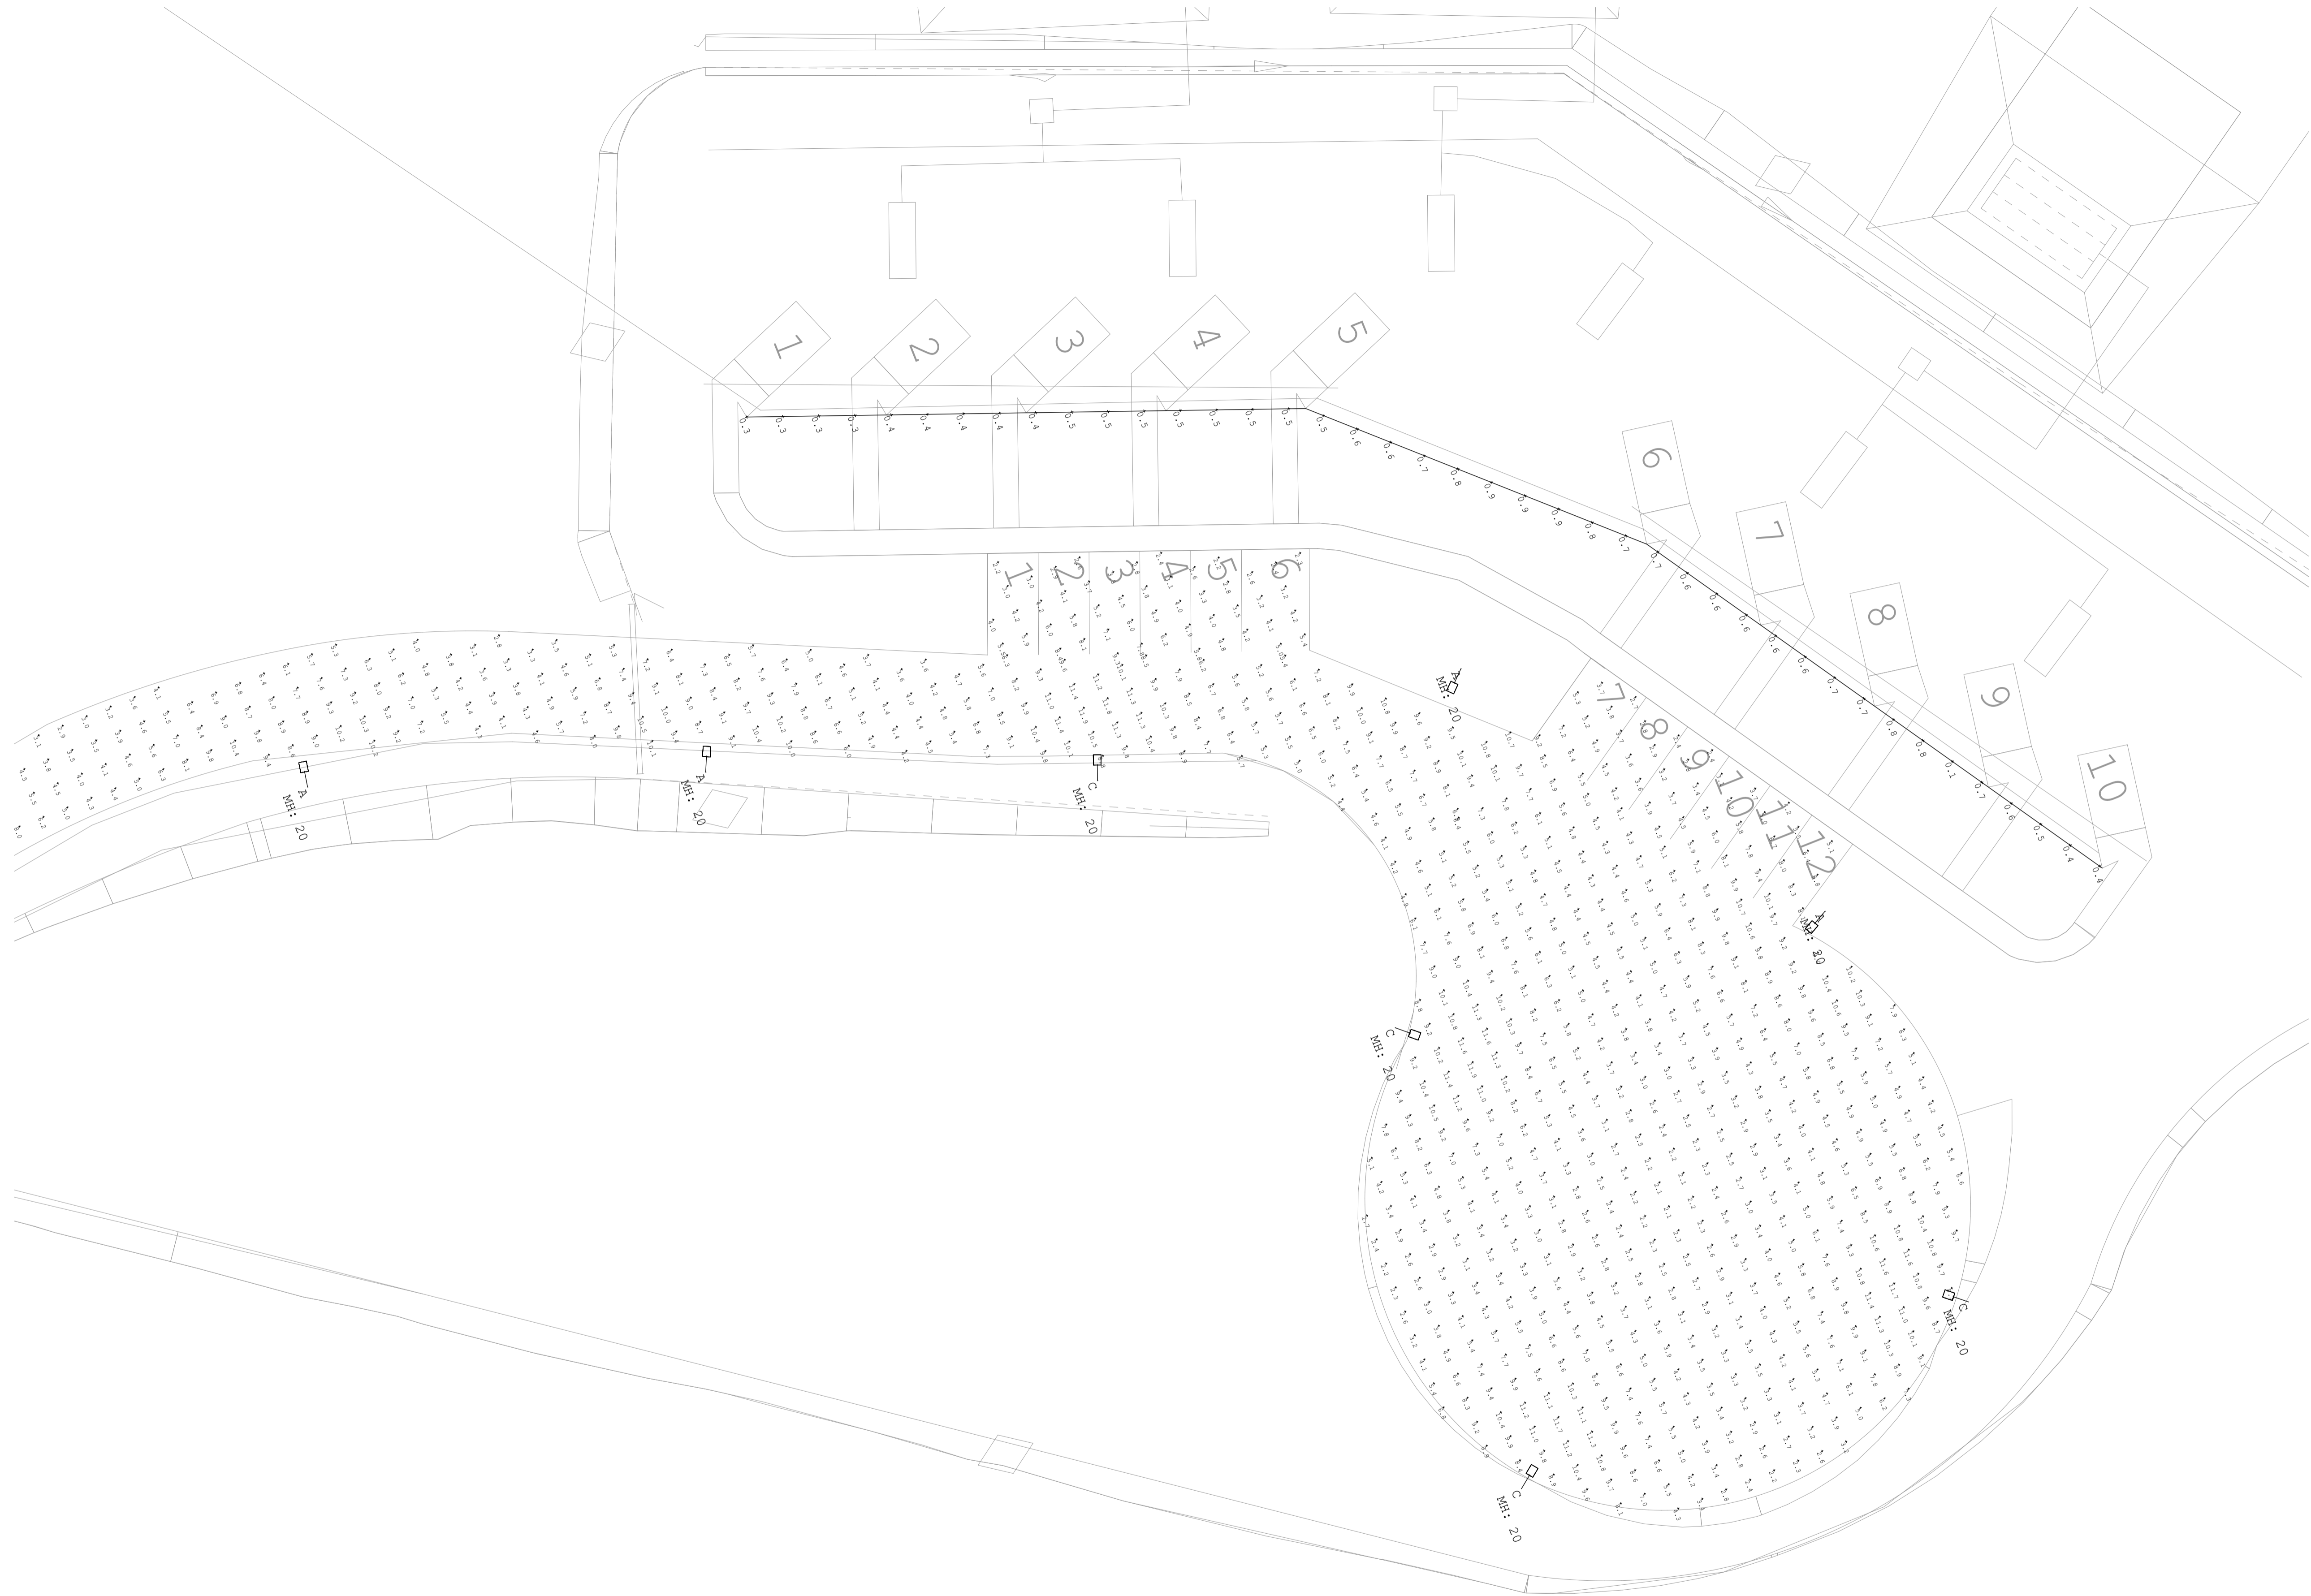

1 LIGHTING PLAN - PHOTOMETRICS
 E-002 SCALE: 1:200

REVISION	DESCRIPTION	DATE
03	RE-ISSUED FOR SITE PLAN APPROVAL	25/08/08
02	RE-ISSUED FOR SITE PLAN APPROVAL	25/01/14
01	ISSUED FOR SITE PLAN APPROVAL	24/12/12

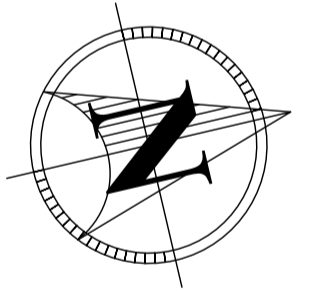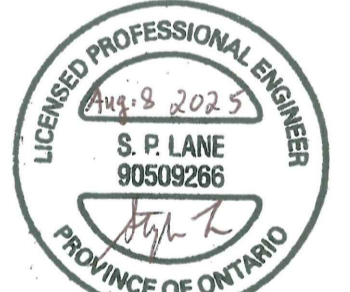NORTH	STAMP
	

PROJECT
 5738 COUNTY ROAD 1,
 LAKESIDE COTTAGES
 CONSECON, ON
 AZZORYPA GP. INC.
 PRICE EDWARD COUNTY, ON

DRAWING TITLE
 LIGHTING PLAN
 PHOTOMETRICS

DESIGNED BY
 S. LANE

DRAWN BY
 T. FUNARI

REVIEWED BY
 S. LANE


APPROVED BY
 S. LANE

PROJECT DATE
 2024/10/06
(YYYY/MM/DD)

PROJECT #
 24-5-6273

DRAWING # E-002	DRAWING SCALE (ISO A1) HOR: AS SHOWN VER: AS SHOWN
--------------------	--

FILE PATH: \\S:\04\2025\25-575A - Elicott Realty - 5738 County Road 1\05 Drawings\Ongoing\25-575A - 5738 CR1 - Electrical - Current.dwg
 DATE PLOTTED: 2025 / 08 / 12 @ 03:06 PM
 PLOT SCALE: 1:1
 BORDER SIZE: ISO A1 (841mm x 594mm)

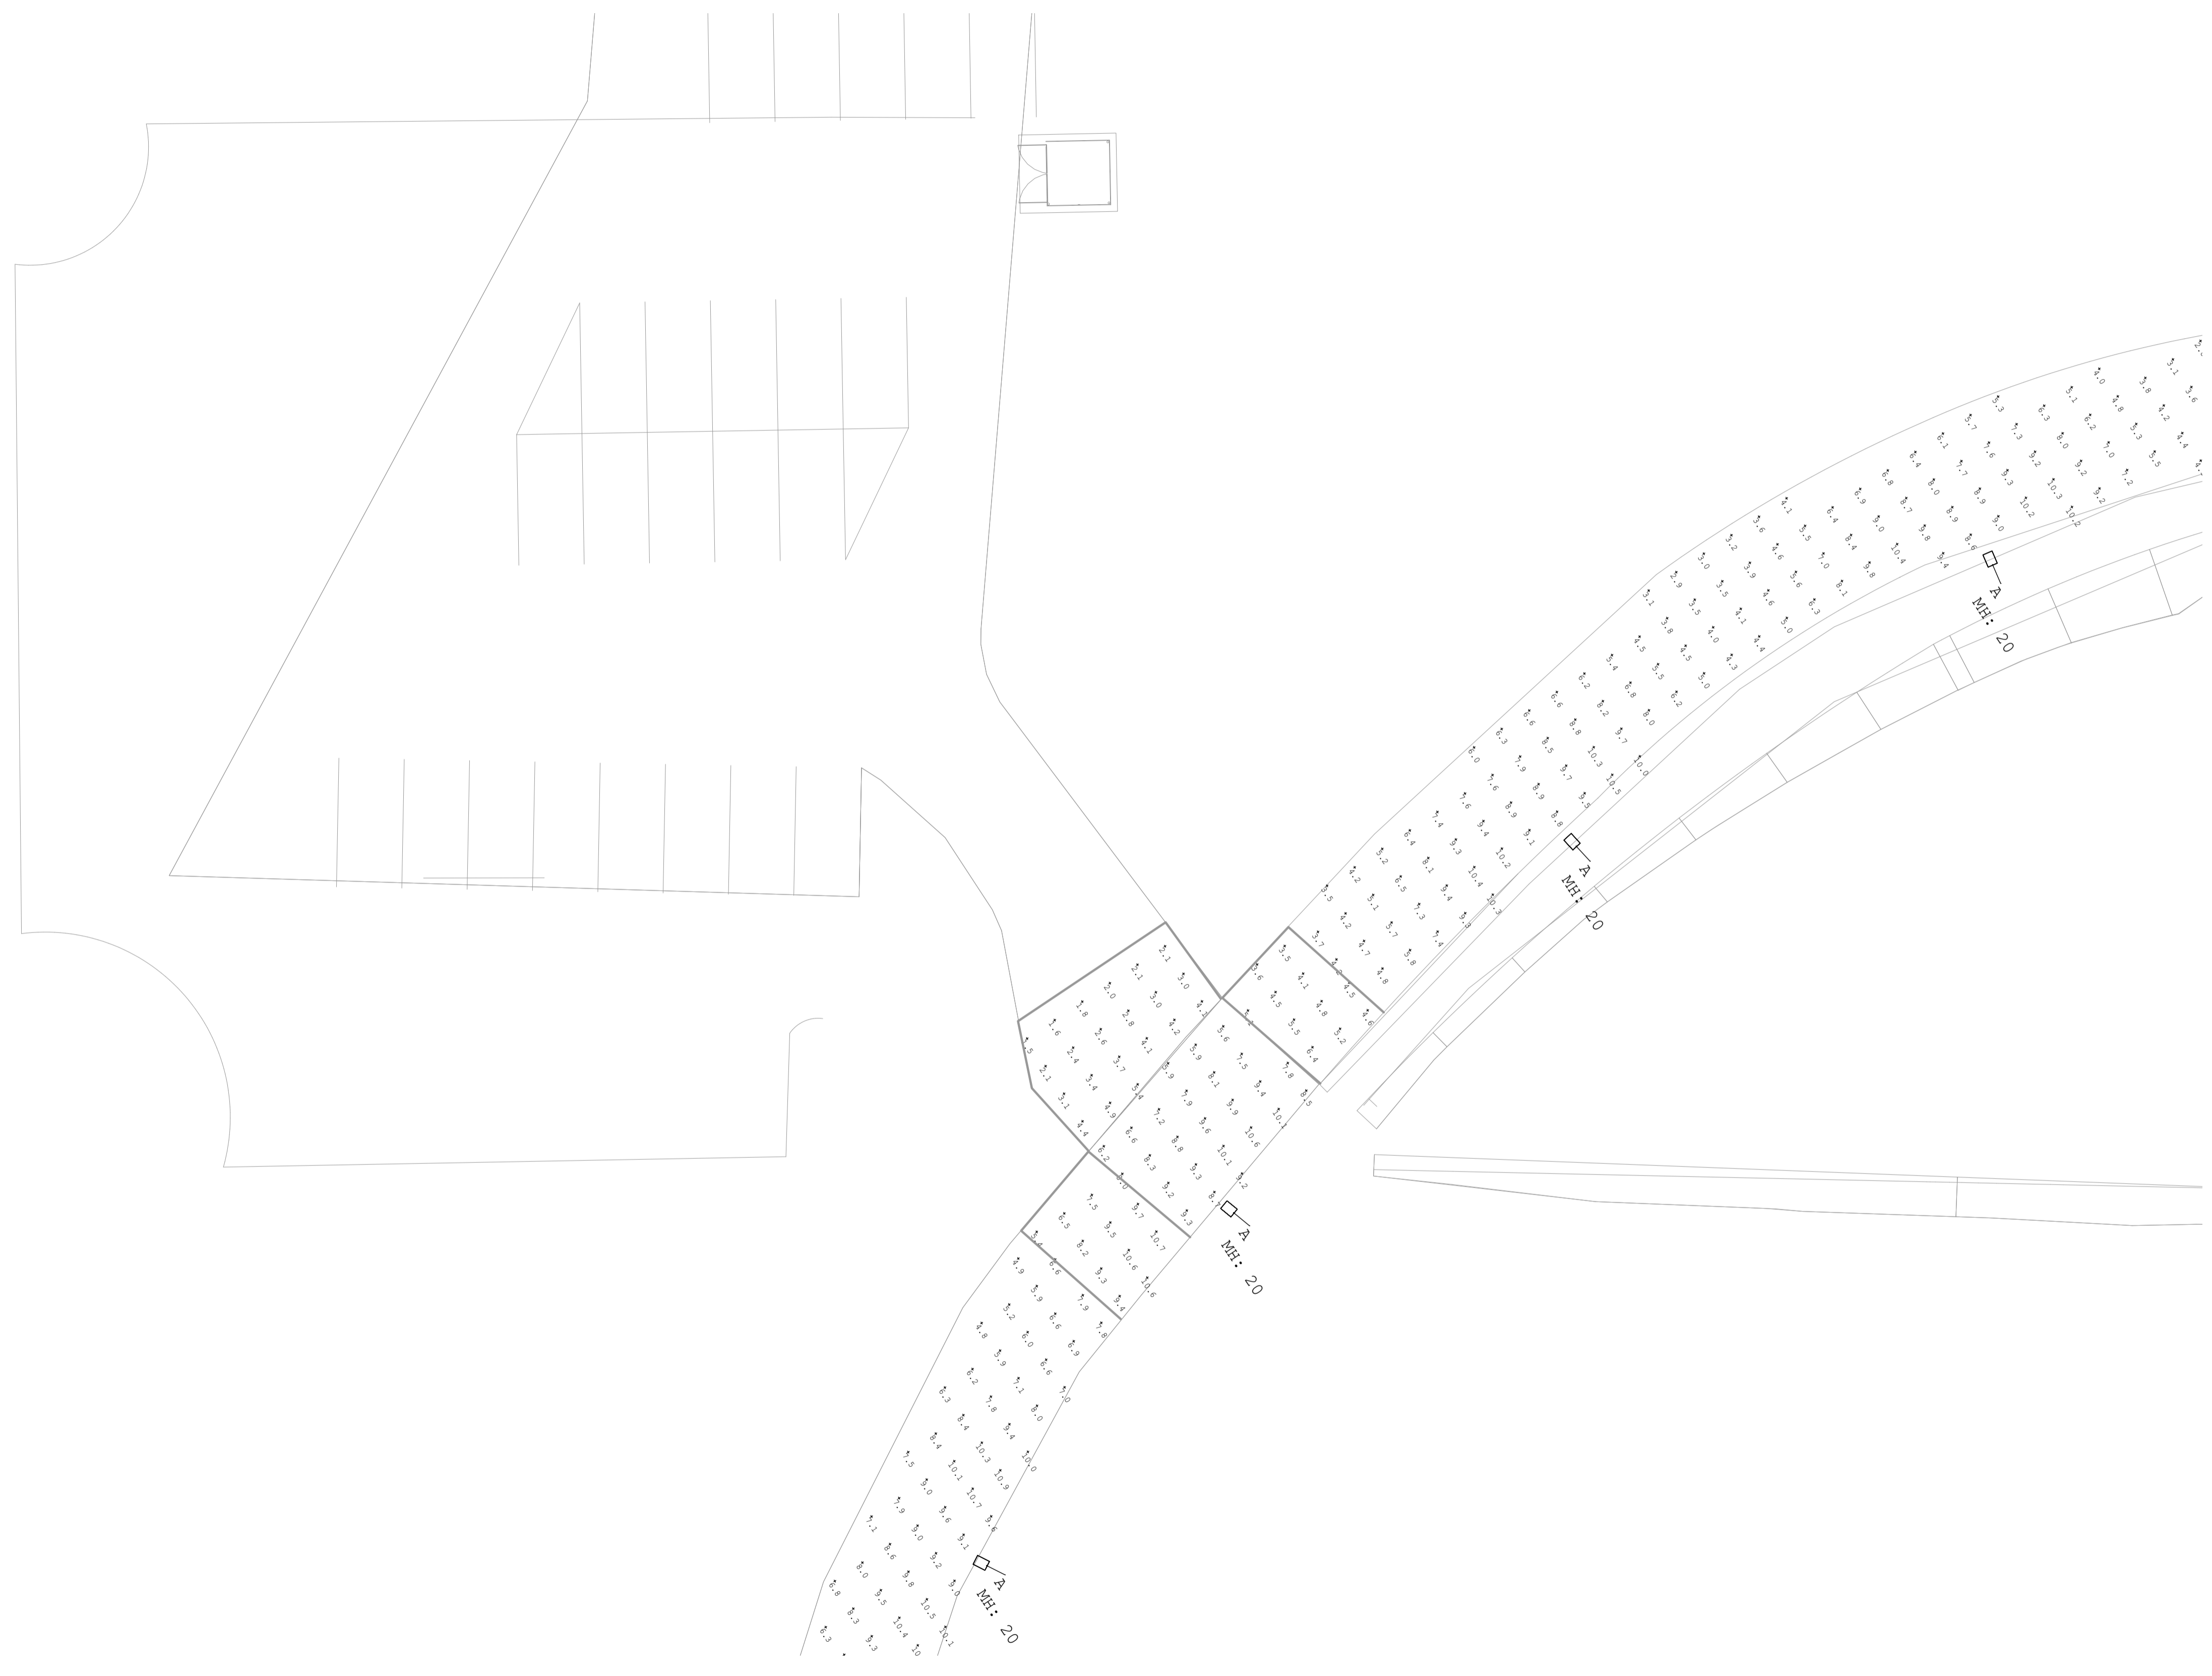

2 LIGHTING PLAN - PHOTOMETRICS
E-003 SCALE: 1:175

- NOTES:
1. ALL WORK SHALL BE IN ACCORDANCE WITH RELEVANT CODES AND GUIDELINES.
 2. ALL DRAWINGS AND ADDENDA ARE TO BE READ AS, AND IN CONJUNCTION WITH THE SPECIFICATIONS.
 3. ALL EQUIPMENT SHALL BE INSTALLED AS SPECIFIED OR APPROVED EQUIVALENT.
 4. CONTRACTOR MUST CHECK AND VERIFY ALL DIMENSIONS BEFORE PROCEEDING WITH WORK AND BE RESPONSIBLE FOR SAME.
 5. CONTRACTOR MUST REPORT ANY DISCREPANCIES TO ENGINEER FOR RESOLUTION BEFORE COMMENCING THE WORK.
 6. ANY CHANGES MUST BE APPROVED BY THE ENGINEER.

A A DETAIL NO.
B B DRAWING NO. - WHERE DETAILED

REVISION	DESCRIPTION	DATE
03	RE-ISSUED FOR SITE PLAN APPROVAL	25/08/08
02	RE-ISSUED FOR SITE PLAN APPROVAL	25/01/14
01	ISSUED FOR SITE PLAN APPROVAL	24/12/12

NORTH	STAMP

PROJECT
 5738 COUNTY ROAD 1,
 LAKESIDE COTTAGES
 CONSECON, ON
 AZZORYPA GP. INC.
 PRICE EDWARD COUNTY, ON

DRAWING TITLE
 LIGHTING PLAN
 PHOTOMETRICS

DESIGNED BY
 S. LANE

DRAWN BY
 T. FUNARI

REVIEWED BY
 S. LANE

APPROVED BY
 S. LANE

PROJECT DATE
 2024/10/06
(YYYY/MM/DD)

PROJECT #
 24-5-6273

DRAWING # E-003	DRAWING SCALE (ISO A1) HOR: AS SHOWN VER: AS SHOWN
--------------------	--



3 LIGHTING PLAN - PHOTOMETRICS
E-004 SCALE: 1:200

- NOTES:
1. ALL WORK SHALL BE IN ACCORDANCE WITH RELEVANT CODES AND GUIDELINES.
 2. ALL DRAWINGS AND ADDENDA ARE TO BE READ AS, AND IN CONJUNCTION WITH THE SPECIFICATIONS.
 3. ALL EQUIPMENT SHALL BE INSTALLED AS SPECIFIED OR APPROVED EQUIVALENT.
 4. CONTRACTOR MUST CHECK AND VERIFY ALL DIMENSIONS BEFORE PROCEEDING WITH WORK AND BE RESPONSIBLE FOR SAME.
 5. CONTRACTOR MUST REPORT ANY DISCREPANCIES TO ENGINEER FOR RESOLUTION BEFORE COMMENCING THE WORK.
 6. ANY CHANGES MUST BE APPROVED BY THE ENGINEER.

A A DETAIL NO.
B B DRAWING NO. - WHERE DETAILED

REVISION	DESCRIPTION	DATE
03	RE-ISSUED FOR SITE PLAN APPROVAL	25/08/08
02	RE-ISSUED FOR SITE PLAN APPROVAL	25/01/14
01	ISSUED FOR SITE PLAN APPROVAL	24/12/12

NORTH 	STAMP
-----------	-----------

PROJECT
5738 COUNTY ROAD 1,
LAKESIDE COTTAGES
CONSECON, ON
AZZORYPA GP. INC.
PRICE EDWARD COUNTY, ON

DRAWING TITLE
LIGHTING PLAN
PHOTOMETRICS

DESIGNED BY
S. LANE

DRAWN BY
T. FUNARI

REVIEWED BY
S. LANE

APPROVED BY
S. LANE

PROJECT DATE
2024/10/06
(YYYY/MM/DD)

PROJECT #
24-5-6273

DRAWING # E-004	DRAWING SCALE (ISO A1) HOR: AS SHOWN VER: AS SHOWN
--------------------	--