


SPA 3RD SUBMISSION CAMPFIRE CIRCLE WESLEY ACRES MEDICAL CAMPSITE

AUG. 18TH, 2026

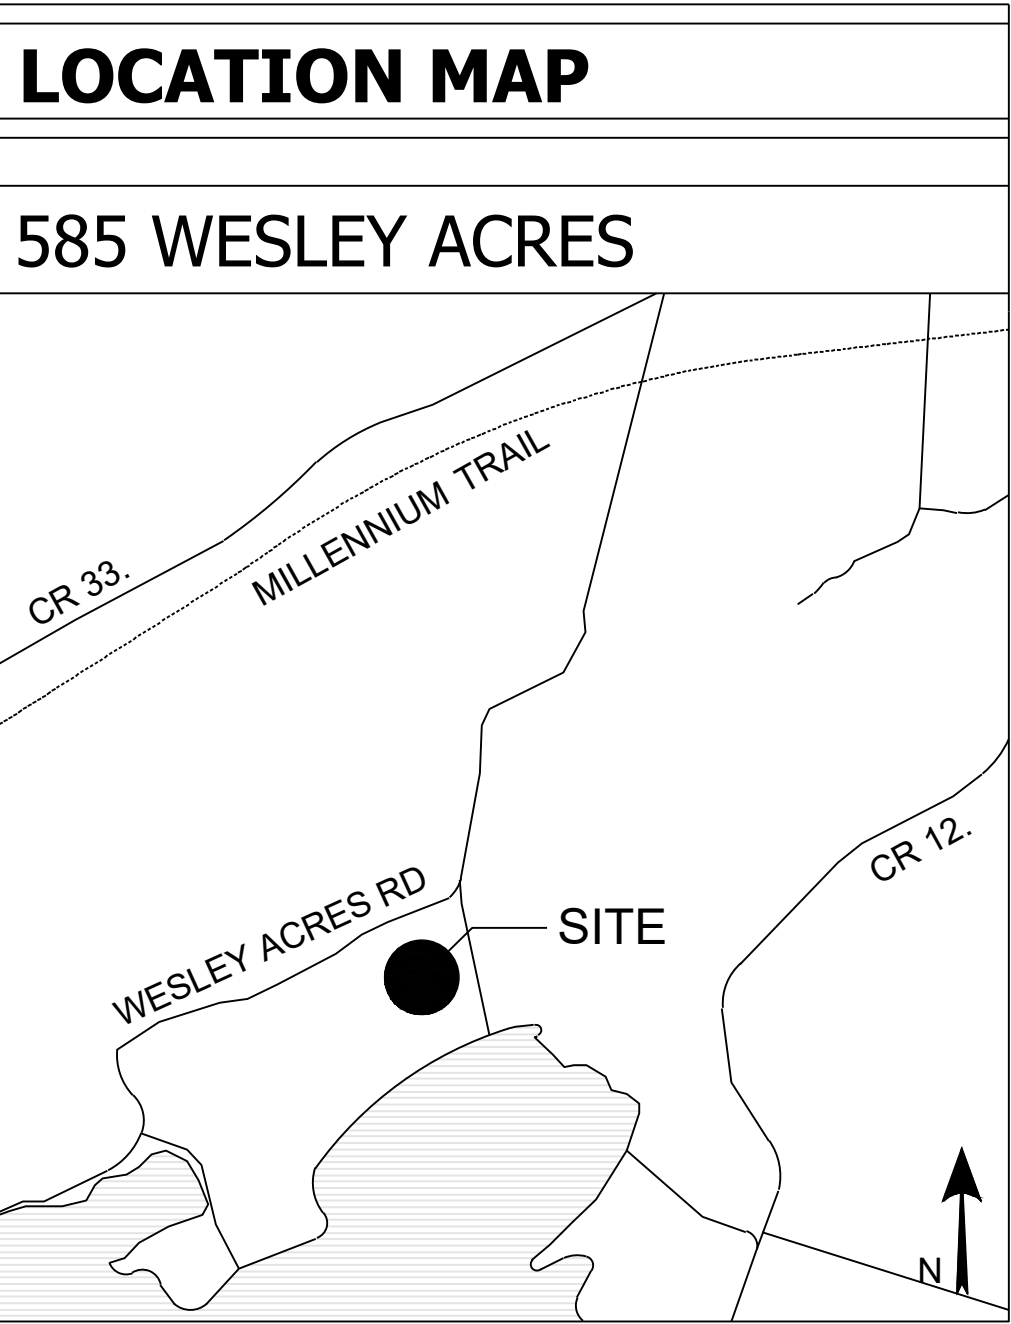

DRAWING INDEX	
** Drawing Print Size: Arch D - 610 mm x 914 mm (24"x36") **	
DRAWING NUMBER	DRAWING TITLE
	TITLE SHEET
L0.1	NOTES AND LEGEND
L1.0	OVERALL LANDSCAPE PLAN
L1.1	LANDSCAPE GRADING PLAN
L1.2	TREE PLANTING PLAN
L2.0	FOREST ENHANCEMENTS AND TREE PLANTING APPROACH
L2.1	WETLAND ENHANCEMENTS
L2.2	MEADOW/GRASSLAND ENHANCEMENTS
L2.3	VEGETATIVE SCREENING
L2.4	STORMWATER MANAGEMENT
L2.5	SPECIES HABITAT ENHANCEMENTS
L3.0	LANDSCAPE ENLARGEMENTS KEY PLAN
L3.1	LANDSCAPE ENLARGEMENT PLAN (1 OF 4)
L3.2	LANDSCAPE ENLARGEMENT PLAN (2 OF 4)
L3.3	LANDSCAPE ENLARGEMENT PLAN (3 OF 4)
L3.4	LANDSCAPE ENLARGEMENT PLAN (4 OF 4)

NATIVE SEED MIXTURE NOTES:

SEED MIX 1:
GRAHAM TURF SEEDS LTD. OPTI PASTURE MIX

- CONTAINING: ANJO TIMOTHY, SHOCKWAVE BR ALFALFA, ARSENAL MEADOW BROME, BRONSON SL TALL FESCUE, SORAYA PERENNIAL RYEGRASS, KAKARIKI LADINO WHITE CLOVER, HUIA WHITE CLOVER

SEED MIX 2:
OSC LOW MAINTENANCE RETENTION BASIN NATIVE SEED MIXTURE 8220

- CONTAINING: POA PALUSTRIS, CAREX VULPINOIDEA, AND ELYMUS VIGINICUS.
- APPLY AT A RATE OF 500g/180 m2 OR 25kg/Ha.
- COMBINE WITH VIRGINIA WILD RYE GRASS, APPLY AT A RATE OF 20LBS/ACRE AND ECO-LAWN SEED BLEND APPLY AT 5LBS/1,000 S.F.
- HYDRO MULCH USING BONDED FIBRE MATRIX APPLIED AT A RATE OF 4,000 LBS/ACRE .

SEEX MIX 3:
WILLIAMS NURSERY AND ECOLOGY CENTRE TALLGRASS PRAIRIE SEED MIX

- CONTAINING: SORGHASTRUM NUTANS, ANDROPOGON GERARDII, PANICUM VIRGATUM, ELYMUS VIRGINICUS, ELYMUS CANADENSIS, SCHIZACHYRIUM SCOPARIUM, OENOTHERA BIENNIS, PENSTEMON DIGITALIS, RUDBECKIA HIRTA, LESPEDEZA CAPITATA, CEANOTHUS AMERICANUS, DESMODIUM CANADENSE, SOLIDAGO PTARMICOIDES, PENSTEMON HIRSUTUS, DOELLINGERIA UMBELLATA, DESMODIUM PANICULATUM, SPOROBOLUS CRYPTANDRUS, PYCNANTHEMUM VIRGINIANUM, POTENTILLA ARGUTA, SOLIDAGO NEMORALIS, RATIBIDA PINNATA, COREOPSIS TRIPTERIS, SYMPHYOTRICHUM LAEVE , SOLIDAGO RIGIDA, GEUM TRIFLORUM, EUPATORIUM MACULATUM, MONARDA FISTULOSA, SOLIDAGO JUNCEA, LIATRIS SPICATA, SILPHIUM TEREBINTHINACEUM, ELYMUS TRACHYCAULUS, BOUTELOUA CURTIPENDULA, ECHINACEA PALLIDA, LESPEDEZA HIRTA, MONARDA PUNCTATA, AND PYCNANTHEMUM TENUIFOLIUM
- APPLY AT A RATE OF 8-10 kg/Ha

SEED MIX 4:
OSC MEDIUM HEIGHT PRAIRIE GRASS NATIVE SEED MIXTURE 8130

- CONTAINING: ANDROPOGON GERARDII, SORGHASTRUM NUTANS, SCHIZACHYRIUM SCOPARIUM, SPARTINA PECTINATA, PANICUM VIRGATUM.
- APPLY AT A RATE OF 500g/180 m2 OF 25kg/Ha.
- COMBINE WITH VIRGINIA WILD RYE GRASS, APPLY AT A RATE OF 20LBS/ACRE AND ECO-LAWN SEED BLEND APPLY AT 5LBS/1,000 S.F.
- HYDRO MULCH USING BONDED FIBRE MATRIX APPLIED AT A RATE OF 4,000 LBS/ACRE.

SEED MIX 5:
OSC SLOPE AND HILLSIDE NATIVE SEED MIXTURE 8225

- CONTAINING: AGROSTIS PERENNANS, RUDBECKIA HIRTA, ELYMUS HYSTRIX, SCHIZACHYRIUM SCOPARIUM, ASTER NOVAE-ANGLAIE, AVENA SATIVA, MONARDA FISTULOSA.
- APPLY AT A RATE OF 500g/180 m2 OF 25kg/Ha.
- COMBINE WITH VIRGINIA WILD RYE GRASS, APPLY AT A RATE OF 20LBS/ACRE AND ECO-LAWN SEED BLEND APPLY AT 5LBS/1,000 S.F.

HYDRO MULCH USING BONDED FIBRE MATRIX APPLIED AT A RATE OF 4,000 LBS/ACRE.

SPECIES HABITAT ENHANCEMENTS GENERAL NOTES (REFER TO L2.5):

1. TURTLE EXCLUSION FENCING INCLUDED ALONG ROADWAY AND PARKING LOT AREAS, AS RECOMMENDATIONS IN THE EIS REPORT, EXACT LOCATION OF THE FENCING TO BE FINALIZED.
2. AVOID LIGHTING NEAR ROOSTING/NESTING ZONES IN THE FOREST AND ALONG FOREST EDGE.
3. NATIVE MEADOW MIX TO INCLUDE A VARIETY OF BIODIVERSE PLANTS TO SUPPORT POLLINATORS SUCH AS MONARCH BUTTERFLIES.
4. IN EXISTING FOREST, PRESERVE ANY MATURE OR STANDIG DEAD TREES WITH CAVITIES, PEELING BARK, OR CREVICES FOR LITTLE BROWN MYOTIS HABITAT.
5. INSTALL EDUCATIONAL SIGNAGE ABOUT ANY NEARBY SPECIAL STATUS SPECIES AND THE IMPORTANCE OF KEEPING THEIR HABITAT SAFE.
6. INCLUDE BIRD FEEDERS OF VARIOUS TYPES AND SIZES THROUGHOUT APPROPRIATE OPEN SPACE ON THE SITE, BIRD FEEDER STRUCTURE BUILDING COULD BE OFFERED AS A CAMP ACTIVITY.
7. USE BUFFERS AROUND WETLANDS AND NESTING AREAS TO PREVENT HABITAT DISTURBANCE.
8. IN WETLAND AND SHALLOW WATER ZONES ADD FLOATING LOGS OR LOW ISLANDS FOR NESTING.

WETLAND ENHANCEMENT GENERAL NOTES (REFER TO L2.1):

1. PLANT SELECTION TO PRIORITIZE NATIVE AND NATVAR SPECIES AND SPECIES PEST AND DISEASE RESISTANT.
2. ALL INVASIVE PLANT SPECIES PRESENT WITHIN THE EXISTING WETLAND AREAS TO BE REMOVED AND REPLACED WITH NATIVE ALTERNATIVES.
3. FOR CATTAIL, REPLANT WITH SPECIES THAT WILL ESTABLISH QUICKLY, TOLERATE FLUCTUATING WATER LEVELS, AND WILL SUPPRESS REGROWTH OF INVASIVE SPECIES SUCH AS SOFT-STEM BULRUSH, HARD-STEM BULRUSH, PICKERELWEED, ARROWHEAD, BLUE FLAG IRIS, MARSH MARIGOLD, AND WATER PLANTAIN.
4. IN WET MEADOW, MARSH EDGE, AND TRANSITIONAL ZONE RESTORE SEDGES, RUSHES, WET GRASSES, LOW SHRUBS, AND PLANT NATIVE WETLAND POLLINATOR SPECIES TO ENHANCE BIODIVERSITY SUCH AS CAREX STRICTA, ASCLEPIAS INCARNATA, EUPATORIUM MACULATUM, VERBENA HASTATA, AND JUNCUS EFFUSUS.
5. RESTORE STRUCTURAL DIVERSITY BY INTRODUCING SMALL OPEN WATER POCKETS FOR BIRD FORAGING, ADDING WOODY DEBRIS AND FLOATING LOGS FOR TURTLES AND BIRDS, AND CREATE LOW-NESTING MOUNDS/ISLANDS.
6. RIPARIAN NATIVE PLANT BUFFER ALONG WATERS EDGE TO HELP WITH FLOODPLAIN FUNCTIONS AND CONSERVE AQUATIC ECOSYSTEMS. PLANTING TO INCLUDE CORNUS SERICEA, CEPHALANTHUS OCCIDENTALIS, CALAMAGROSTIS CANADENSIS, SPIRAEA ALBA.
7. ALL WETLAND ENHANCEMENT AND RESTORATION WORK INTENDED TO BE PURSUED IN COLLABORATION WITH QUINTE CONSERVATION AUTHORITY AND ECOLOGICAL SERVICES.
8. EXACT LOCATIONS OF ENHANCEMENT AREAS TO BE REFINED WITH FURTHER DEVELOPMENT AND THROUGH DETAILED DESIGN.

PLANTING GENERAL NOTES (REFER TO L1.2, L2.0, AND L2.3):

1. REPLACE SPECIFIED EXISTING LAWN AREAS AND DEGRADED FARMLAND WITH NATIVE VEGETATION AND MEADOW SEED MIX TO INCREASE BIODIVERSITY.
2. ESTABLISH SELF-SUSTAINING, LOW MAINTENANCE PLANT COMMUNITIES THAT OVER TIME WILL IMPROVE SOIL STRUCTURE.
3. NATIVE PRAIRIE SEED MIX TO INCLUDE HERBACEOUS PLANTS WITH FIBROUS ROOT SYSTEMS TO HELP WITH SLOPE STABILIZATION AND PREVENT EROSION.
4. PLANT SELECTION TO PRIORITIZE NATIVE AND NATVAR SPECIES AND SPECIES PEST AND DISEASE RESISTANT.
5. ALL INVASIVE PLANT SPECIES EXISTING WITHIN THE EXISTING FOREST AREAS TO BE REMOVED AND REPLACED WITH NATIVE ALTERNATIVES.
6. 206 TREES HAVE BEEN PROPOSED TO ACCOUNT FOR REQUIRED TREE REPLACEMENTS OF EXISTING TREES.
7. SMALLER-CALIPER TREE WHIPS AND PLUGS HAVE BEEN PROPOSED TO REDUCE UPFRONT INVESTMENT WHILE ALLOWING THE LANDSCAPE TO ESTABLISH GRADUALLY OVER TIME.

GRADING GENERAL NOTES (REFER TO L1.1):

1. FOR ADDITIONAL GRADING INFORMATION, REFER TO CIVIL ENGINEERING DRAWINGS SG-1 THROUGH SG-4.
2. FOR SITE SERVICING INFORMATION, REFER TO CIVIL ENGINEERING DRAWINGS SS-1 THROUGH SS-4.
3. CONTRACTOR TO CONFIRM TRAIL ALIGNMENTS THROUGH EXISTING FORESTED AREAS WITH LANDSCAPE ARCHITECT AND ARBORIST PRIOR TO ANY SITE PREPARATION OR TRAIL INSTALLATION ACTIVITIES.

 
STORMWATER ENHANCEMENTS GENERAL NOTES (REFER TO L2.4):

1. STORMWATER MITIGATION TO BE MANAGED USING BEST MANAGEMENT PRACTICES REFLECTING LOW IMPACT DESIGN GUIDELINES.
2. STORMWATER PLAN TO COINCIDE WITH ENGINEERING STORMWATER MANAGEMENT PLAN.
3. RAIN GARDENS, ENHANCED GRASS SWALES, AND VEGETATED FILTER STRIPS TO BE USED IN ACCORDINACE WITH MOECC GUIDELINES.
4. PROMOTE INFILTRATION STRATEGIES TO REDUCE SALT WATER RUN-OFF INTO LAKE USING SALT-TOLERANT PLANTS.

LIGHTING NOTES:

1. REFER TO LIGHTING PHOTOMETRIC PLAN PROVIDED BY S+A FOR FIXTURE LOCATIONS, SPECIFICATIONS, PHOTOMETRICS, STATISTICS, AND SCHEDULE.
2. LANDSCAPE LIGHTING TO COMPLY WITH ALL MUNICIPAL BYLAWS AND DARK SKY GUIDELINES.
3. LIGHTING TO BE INSTALLED IN ACCORDANCE WITH MANUFACTURERS RECOMMENDATIONS.

LEGEND



SODDED LAWN AREA



BUFFER/SCREENING PLANTING



SHRUB AND PERENNIAL PLANTING



 
VEGETATIVE INFILTRATION
ENHANCEMENT PLANTING



SMALL-CALIPER
TREE WHIP OR PLUG PLANTING



DECIDUOUS TREE PLANTING



CONIFEROUS TREE PLANTING



EXISTING VEGETATION



 
EXISTING TREE TO REMAIN



GATHERING NODE



ARMOUR STONE BOULDERS




LIGHT FIXTURE,
REFER TO ELECTRICAL




SEEDING MIX 1
OPTI PASTURE MIX
GRAHAM TURF SEEDS LTD.



 SEEDING MIX 2
OSC LOW MAINTENANCE RETENTION
BASIN NATIVE SEED MIX 8220



 
SEEDING MIX 3
TALLGRASS PRAIRIE SEED MIX
ST. WILLIAMS NURSERY AND
ECOLOGY CENTRE



SEEDING MIX 4
OSC MEDIUM HEIGHT PRAIRIE
GRASS NATIVE SEED MIX 8130



 SEEDING MIX 5
OSC NATIVE SLOPE AND
HILLSIDE 8225




RIPARIAN ENHANCEMENT ZONE



ASPHALT PAVING



 CONCRETE PAVING



CONCRETE UNIT PAVING
TYPE A



CONCRETE UNIT PAVING
TYPE B



GRAVEL



RIVERSTONE MULCH



WOODEN BOARDWALK

6m EROSION HAZARD SETBACK

100 YEAR FLOOD ELEVATION

300mm HT. BERM

EP LIMIT

EROSION HAZARD LIMIT

PROPERTY LINE

PROPOSED TOP/BOTTOM OF STORM DITCH

PROPOSED SANI LINE

PROPOSED STORM LINE

PROPOSED UNDERGROUND UTILITY LINE

PROPOSED WATER LINE

ROOF OUTLINE ABOVE

FENCING - AROUND PASTURE

FENCING - SECURITY

FENCING - TURTLE EXCLUSION


SNOW STORAGE

TOP/BOTTOM OF SLOPE

TOP/BOTTOM OF STORM DITCH


WAVE UPRUSH SETBACK

WETLAND SETBACK

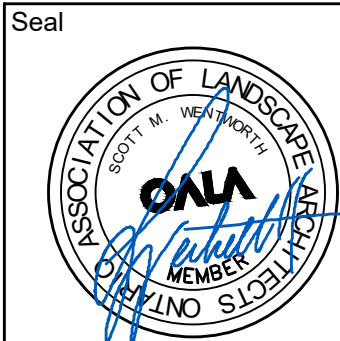

North

No.	Issues and Revisions	Date
1.	ISSUED FOR SPA	2025-08-15
2.	ISSUED FOR COORDINATION	2026-01-27
3.	REISSUED FOR SPA	2026-02-06
4.	REISSUED FOR COORDINATION	2026-07-28
5.	ISSUED FOR SPA - 3RD SUBMISSION	2026-08-18

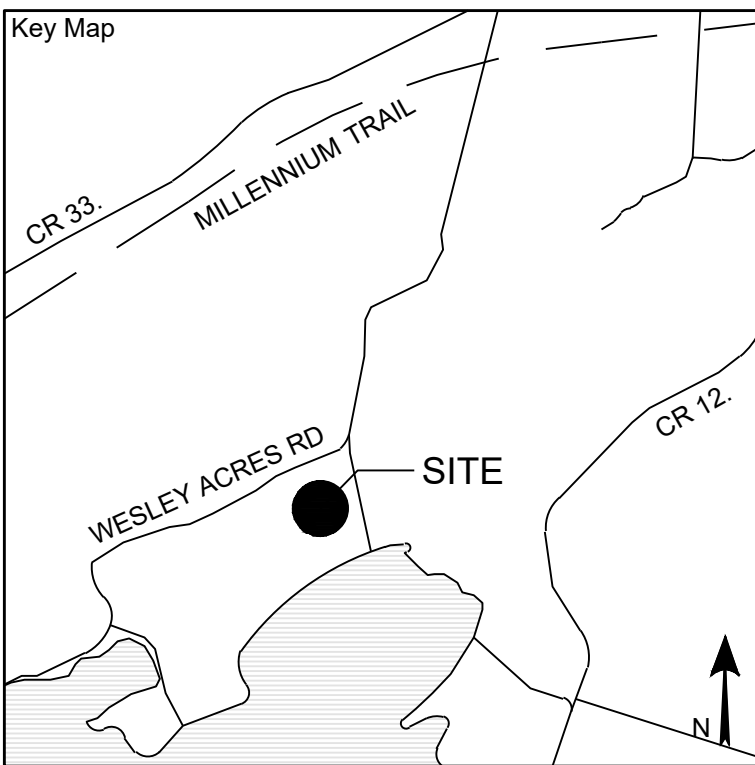

Project Notes

This design and drawing are the property of The Scott Wentworth Landscapes Group Ltd. and are not to be copied or used for construction purposes without the Landscape Architect's express written consent.

The contractor shall check and verify all dimensions and report any discrepancies, error, or omissions to the Landscape Architect prior to commencing work.

Base plan information taken from Site Plan provided by:
Company Name:
Dated:


Wentworth Landscapes
13392 Loyalist Parkway R.R.1, Picton ON K0K 2T0
613.547.3772

Consultants




Client: CAMPFIRE CIRCLE	
Project: CAMPFIRE CIRCLE	
Project Location: 565 WESLEY ACRES ROAD BLOOMFIELD, ON	
Drawing Title: NOTES AND LEGEND	
Scale: N/A	
Date: 2025-06-25	Plot Date: 2026-08-18
Designed By: MH	Drawn By: PL/LT
Approved By: SW	Drawing Number: L0.1
Project Number: 23011-DC	

G:\Shared drives\Commercial\Department02 - PROJECTS\2023\23011-DC - Campfire Circle - SWSHEET SET\23011-DC - Campfire Circle - L1.0 - Landscape Plan.dwg

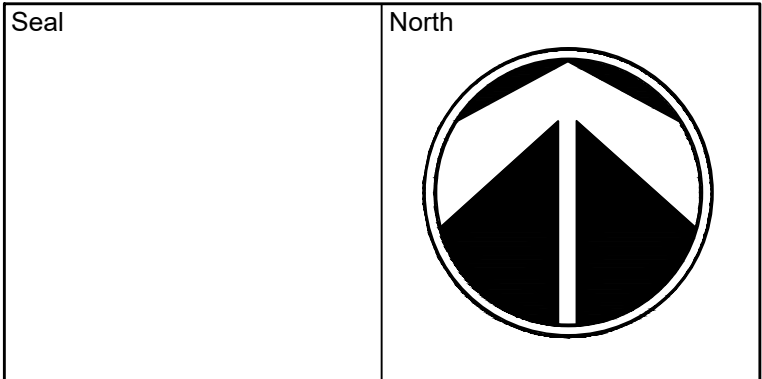

No.	Issues and Revisions	Date
1.	ISSUED FOR SPA	2025-08-15
2.	ISSUED FOR COORDINATION	2026-01-27
3.	REISSUED FOR SPA	2026-02-06
4.	REISSUED FOR COORDINATION	2026-07-28
5.	ISSUED FOR SPA - 3RD SUBMISSION	2026-08-10

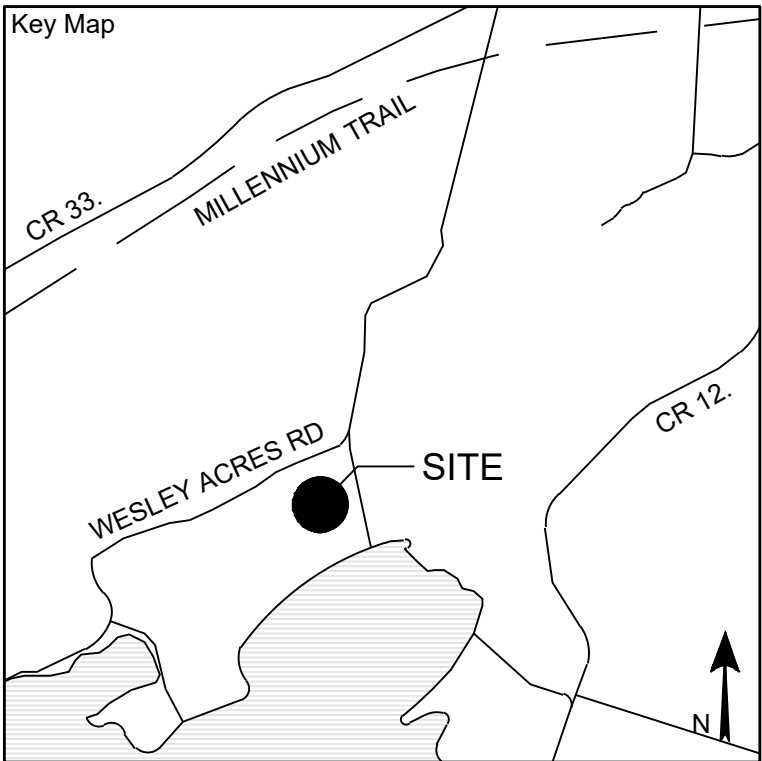

Project Notes
This design and drawing are the property of The Scott Wentworth Landscape Group Ltd. and are not to be copied or used for construction purposes without the Landscape Architect's express written consent.
The contractor shall check and verify all dimensions and report any discrepancies, error, or omissions to the Landscape Architect prior to commencing work.
Base plan information taken from Site Plan provided by:
Company Name:
Dated:


Wentworth Landscapes
13392 Loyalist Parkway R.R.1, Picton ON K0K 2T0
613.547.3772

Consultants



Client	CAMPFIRE CIRCLE
Project	CAMPFIRE CIRCLE
Project Location	565 WESLEY ACRES ROAD BLOOMFIELD, ON
Drawing Title	OVERALL LANDSCAPE PLAN
Scale	1:1500
Date	2025-06-25
Designed By	MH
Approved By	SW
Project Number	23011-DC
Plot Date	2026-08-18
Drawn By	PL/LT
Drawing Number	L1.0


G:\Shared drives\Commercial Department\02 - PROJECTS\2023\23011-DC - Campfire Circle - SWSHEET SET\23011 - Campfire Circle - L1.1 - Grading Plan.dwg

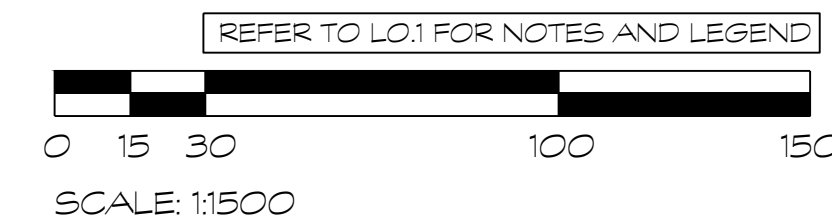

Seal

North

No.	Issues and Revisions	Date
1.	ISSUED FOR SPA	2025-08-15
2.	ISSUED FOR COORDINATION	2026-01-27
3.	REISSUED FOR SPA	2026-02-06
4.	REISSUED FOR COORDINATION	2026-07-28
5.	ISSUED FOR SPA - 3RD SUBMISSION	2026-08-18

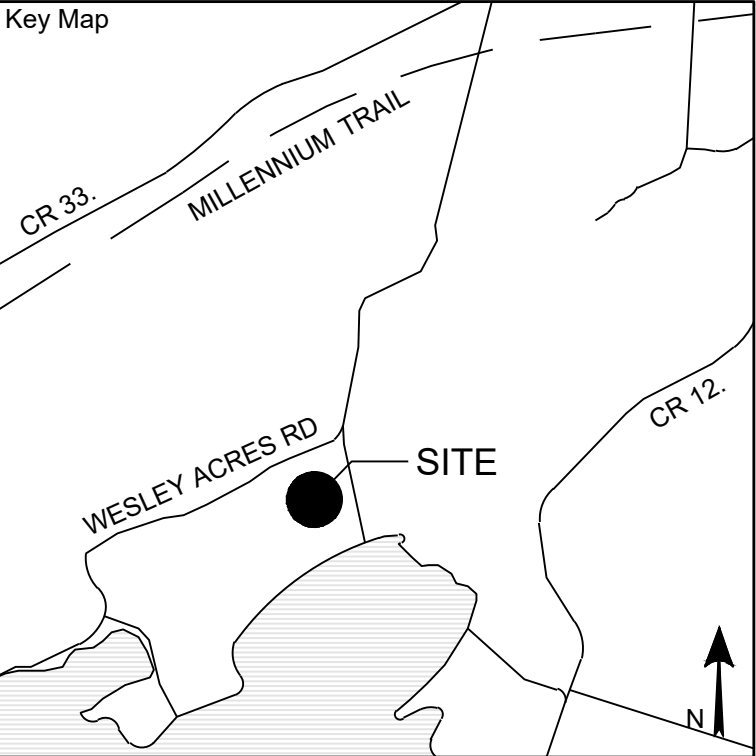

Project Notes

This design and drawing are the property of The Scott Wentworth Landscape Group Ltd. and are not to be copied or used for construction purposes without the Landscape Architect's express written consent.

The contractor shall check and verify all dimensions and report any discrepancies, error, or omissions to the Landscape Architect prior to commencing work.

Base plan information taken from Site Plan provided by:
Company Name:
Dated:

Wentworth Landscapes
13392 Loyalist Parkway R.R.1, Picton ON K0K 2T0
613.547.3772

Consultants




Client CAMPFIRE CIRCLE	
Project CAMPFIRE CIRCLE	
Project Location 565 WESLEY ACRES ROAD BLOOMFIELD, ON	
Drawing Title LANDSCAPE GRADING PLAN	
Scale 1:1500	
Date 2025-08-25	Plot Date 2026-08-28
Designed By MH	Drawn By PL/LT
Approved By SW	Drawing Number
Project Number 23011-DC	L1.1

G:\Shared drives\Commercial Department\02 - PROJECTS\2023\23011-DC - Campfire Circle - SWSHEET SET\23011-DC - Campfire Circle - L1.2 - Tree Planting Plan.dwg


PLANT MATERIAL SCHEDULE - LARGE-CALIPER TREE SPECIES										
SYMBOL	QUANTITY	BOTANICAL NAME	COMMON NAME	SIZE	CONDITION	SPACING**	NATIVE	BIODIVERSITY FACTOR	SUPPORTS POLLINATORS*	ATTRACTS BIRDS
Deciduous Trees										
Ac	21	Amelanchier canadensis	Downy Serviceberry	175cm cal.	WB Clump	As shown	Native	124	Yes	Yes
ARC	3	Acer freemanii 'Cezam'	Celebration Maple	60mm cal.	WB	Min 6m O.C.	Native	225	Yes	Yes
AR	9	Acer freemanii 'Jeffersred'	Autumn Blaze Maple	60mm cal.	WB	As shown	Native	225	Yes	Yes
Ar	13	Acer rubrum	Red Maple	60mm cal.	WB	As shown	Native	225	Yes	Yes
AsA	3	Acer saccharinum***	Silver Maple	60mm cal.	WB	As shown	Native	225	Yes	Yes
As	7	Acer saccharum	Sugar Maple	60mm cal.	WB	As shown	Native	225	Yes	Yes
Bn	26	Betula nigra	River Birch	60mm cal.	WB	As shown	Native	410	Yes	Yes
Cc	10	Cornus alternifolia	Pagoda Dogwood	125cm cal.	7gal	As shown	Native	129	Yes	Yes
Ca	12	Corpinus caroliniana	Blue Beech	60mm cal.	WB	As shown	Native	72	Yes	Yes
CCA	2	Cercis canadensis	Eastern Redbud	175cm cal.	WB Clump	As shown	Native	23	Yes	Yes
Co	16	Celtis occidentalis	Common Hackberry	60mm cal.	WB	As shown	Native	44	Yes	Yes
Fg	5	Fagus grandifolia***	American Beech	60mm cal.	WB	As shown	Native	135	Yes	Yes
Lt	1	Liriodendron tulipifera	Tulip Tree	60mm cal.	WB	As shown	Native	19	Yes	Yes
Mst	2	Malus 'Sugar Tyme' (Gutzam)	Sugar Tyme Flowering Crab Apple	60mm cal.	WB	As shown	Native	309	Yes	Yes
Ns	6	Nyssa sylvatica***	Sourgum	60mm cal.	WB	As shown	Native	55	Yes	Yes
Qv	2	Quercus virginiana***	Ironwood	60mm cal.	WB	As shown	Native	90	Yes	Yes
Pb	2	Populus balsamifera	Balsam Poplar	45mm cal.	WB	As shown	Native	360	Yes	Yes
PoC	3	Populus occidentalis	American Sycamore	60mm cal.	WB	As shown	Native	43	Yes	Yes
Pr	7	Populus tremuloides	Trembling Aspen	60mm cal.	WB	As shown	Native	360	Yes	Yes
PR	1	Ptelea trifoliata	Hop Tree	40mm cal.	WB	As shown	Native	4	Yes	Yes
Qb	3	Quercus bicolor	Swamp White Oak	50mm cal.	WB	As shown	Native	521	Yes	Yes
Qm	1	Quercus macrocarpa	Burr Oak	60mm cal.	WB	As shown	Native	521	Yes	Yes
QmU	2	Quercus muehlenbergii	Chinkapin Oak	50mm cal.	WB	As shown	Native	521	Yes	Yes
Sn	1	Salix nigra	Black Willow	50mm cal.	25gal	As shown	Native	431	Yes	Yes
Ta	9	Tilia americana***	Bosewood	60mm cal.	WB	As shown	Native	160	Yes	Yes
UaB	7	Ulmus americana 'Brandon'	Brandon Elm	60mm cal.	WB	As shown	Native	201	Yes	Yes
UaP	4	Ulmus americana 'Princeton'	Princeton Elm	60mm cal.	WB	As shown	Native	201	Yes	Yes
Coniferous Trees										
Pg	3	Picea glauca	White Spruce	175cm HT.	WB	As shown	Native	156	Yes	Yes
Ps	3	Picea omorika	Serbian Spruce	175cm HT.	WB	Min 4m O.C.	Ornamental	156	Yes	Yes
Ps	4	Pinus strobus*	Eastern White Pine	175cm HT.	WB	As shown	Native	259	Yes	Yes
Ta	10	Thuja occidentalis	Eastern White Cedar	175cm HT.	WB	As shown	Native	46	Yes	Yes

PLANT MATERIAL SCHEDULE - SMALL-CALIPER WHIP TREE SPECIES										
SYMBOL	QUANTITY	BOTANICAL NAME	COMMON NAME	SIZE	CONDITION	SPACING**	NATIVE	BIODIVERSITY FACTOR	SUPPORTS POLLINATORS*	ATTRACTS BIRDS
Deciduous Trees										
As	TBD	Acer saccharum	Sugar Maple		Whip	TBD	Native	225	Yes	Yes
Ar	TBD	Asimina triloba	Common Pawpaw		Whip	TBD	Native	100	Yes	Yes
Ba	TBD	Betula alleghaniensis***	Yellow Birch		Whip	TBD	Native	410	Yes	Yes
Bp	TBD	Betula papyrifera***	Paper Birch		Whip	TBD	Native	410	Yes	Yes
Ca	TBD	Cornus alternifolia	Pagoda Dogwood		Whip	TBD	Native	129	Yes	Yes
Cc	TBD	Corpinus caroliniana	Blue Beech		Whip	TBD	Native	72	Yes	Yes
Co	TBD	Celtis occidentalis	Common Hackberry		Whip	TBD	Native	44	Yes	Yes
CoV	TBD	Carya ovata***	Shagbark Hickory		Whip	TBD	Native	238	Yes	Yes
Fg	TBD	Fagus grandifolia***	American Beech		Whip	TBD	Native	135	Yes	Yes
Gd	TBD	Gymnocladus dioica	Kentucky Coffee Tree		Whip	TBD	Native		Yes	Yes
Pb	TBD	Populus balsamifera	Balsam Poplar		Whip	TBD	Native	360	Yes	Yes
Pr	TBD	Populus tremuloides	Trembling Aspen		Whip	TBD	Native	360	Yes	Yes
Qa	TBD	Quercus alba	White Oak		Whip	TBD	Native	521	Yes	Yes
Qm	TBD	Quercus macrocarpa	Burr Oak		Whip	TBD	Native	521	Yes	Yes
QmU	TBD	Quercus muehlenbergii	Chinkapin Oak		Whip	TBD	Native	521	Yes	Yes
Qp	TBD	Quercus paustriis	Pin Oak		Whip	TBD	Native	521	Yes	Yes
Sa	TBD	Sassafras albidum	Sassafras		Whip	TBD	Native	31	Yes	Yes
Coniferous Trees										
Pm	TBD	Picea mariana	Black Spruce		Whip	TBD	Native	156	Yes	Yes
Pr	TBD	Pinus resinosa	Red Pine		Whip	TBD	Native	259	Yes	Yes
Tc	TBD	Tsuga canadensis	Eastern Hemlock		Whip	TBD	Native	46	Yes	Yes

* Biodiversity Value represents the number of butterfly and moth species the plant hosts. This is essential as caterpillars are the foundation for building the food web and enhancing biodiversity, being the primary food for nesting birds to feed their young. Based upon the research of Dr. Douglas Tallamy, University of Delaware.
** Pollinators also include butterfly and moth species.
*** Exact spacing of tree to be determined.
**** Indicates tree species identified on site as per arborist report.

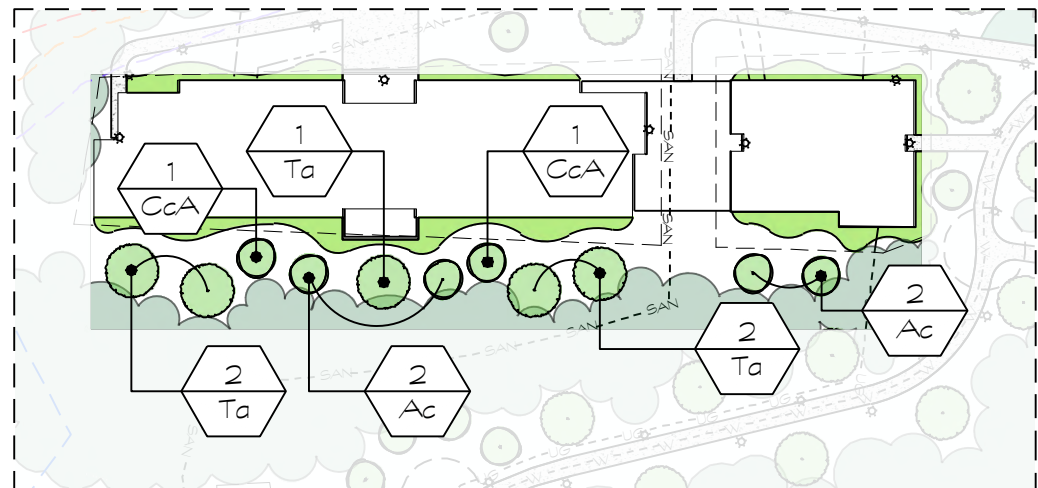


TREE PLANTING ENLARGEMENT PLAN

 


SCALE: 1:1000


REFER TO TREE PLANTING ENLARGEMENT PLAN ABOVE FOR TREE SPECIES AND QUANTITIES IN THIS AREA

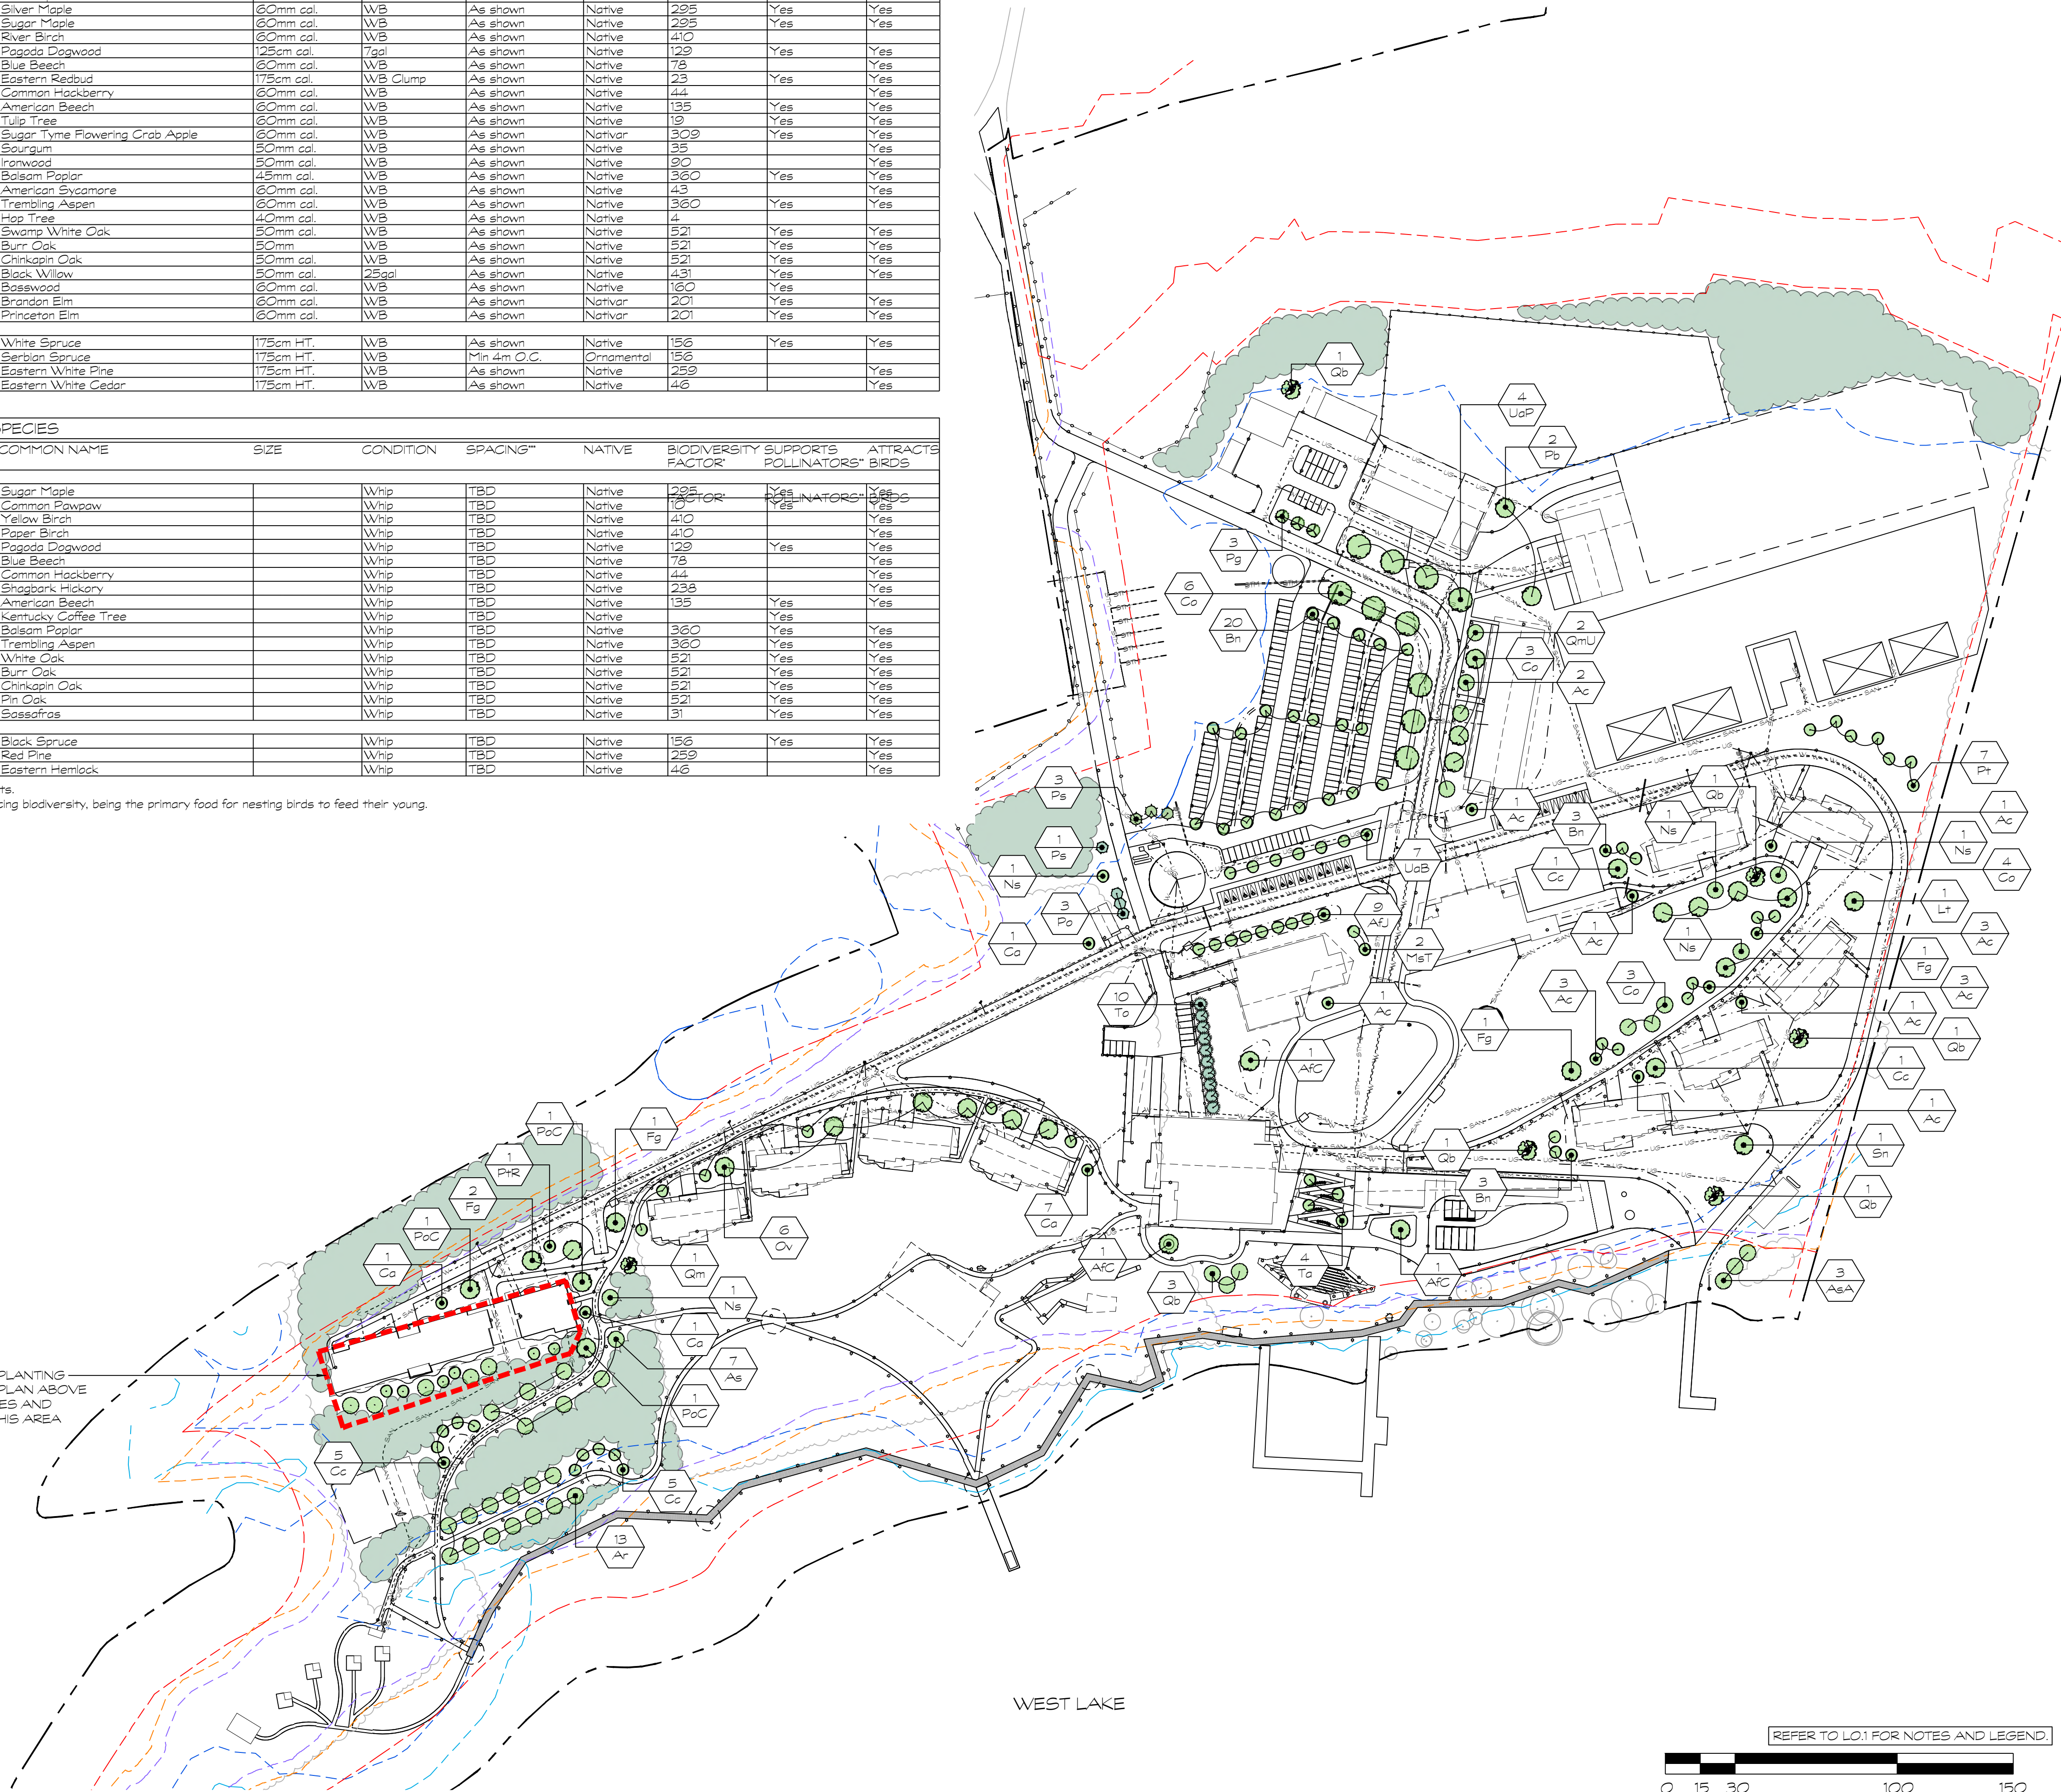

WEST LAKE

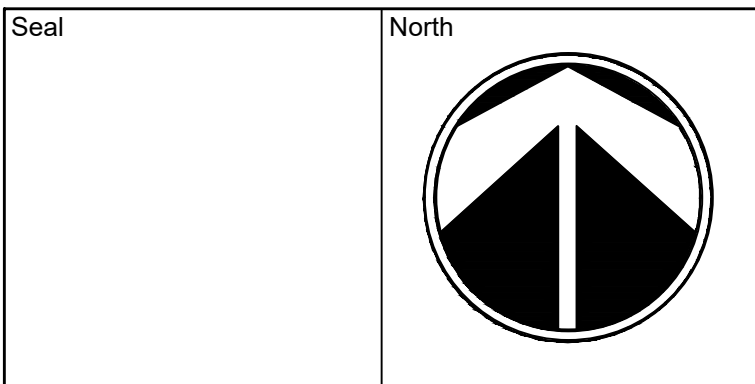

No.	Issues and Revisions	Date
1.	ISSUED FOR SPA	2025-08-15
2.	ISSUED FOR COORDINATION	2026-01-27
3.	REISSUED FOR SPA	2026-02-06
4.	REISSUED FOR COORDINATION	2026-07-28
5.	ISSUED FOR SPA - 3RD SUBMISSION	2026-08-18

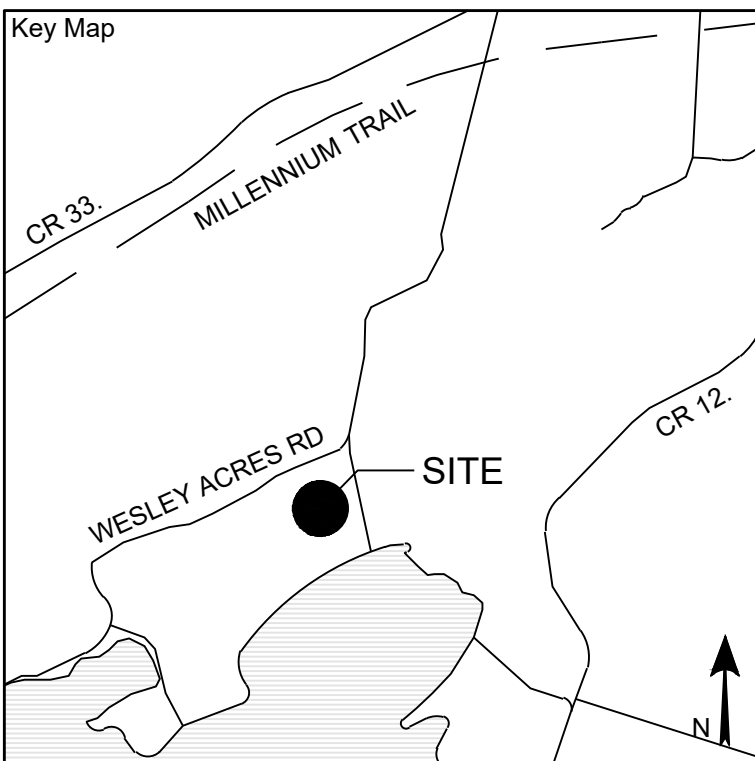

Project Notes
This design and drawing are the property of The Scott Wentworth Landscape Group Ltd. and are not to be copied or used for construction purposes without the Landscape Architect's express written consent.

The contractor shall check and verify all dimensions and report any discrepancies, error, or omissions to the Landscape Architect prior to commencing work.

Base plan information taken from Site Plan provided by:
Company Name:
Dated:

Wentworth Landscapes
13392 Loyalist Parkway R.R.1, Picton ON K0K 2T0
613.547.3772

Consultants



Client CAMPFIRE CIRCLE	
Project CAMPFIRE CIRCLE	
Project Location 565 WESLEY ACRES ROAD BLOOMFIELD, ON	
Drawing Title TREE PLANTING PLAN	
Scale 1:1500	
Date 2025-06-25	Plot Date 2026-08-18
Designed By MH	Drawn By PL/LT
Approved By SW	Drawing Number
Project Number 23011-DC	L1.2

G:\Shared drives\Commercial Department\02 - PROJECTS\2023\23011-DC - Campfire Circle - SWSHEET SET\23011-DC - Campfire Circle - L2.0 - Forest Enhancements.dwg

LEGEND			
	PRESERVED EXISTING FOREST		PROPOSED SMALL-CALIPER TREE WHIP TREE PLANTING
	PRESERVED EXISTING HEDGEROW		PROPOSED FOREST INFILL



SMALL-CALIPER TREE WHIPS PLANTED IN LARGE GROUPINGS WILL CREATE A NATURAL BUFFER AND SUPPORT THE ADJACENT EXISTING PSW.

FAST GROWING TREE SPECIES ALONG MAIN ROADS AND INFRASTRUCTURE PROVIDE RELATIVELY QUICK VISUAL AND ENVIRONMENTAL IMPACT. TREES SELECTED FOR THEIR RESILIENCE TO URBAN CONDITIONS, WIND, AND DROUGHT

TREE PLANTING WITHIN PARKING LOTS, ALONG ROADS, AND PATHWAYS WILL HELP WITH REDUCING THE HEAT ISLAND EFFECT, MANAGE WATER RUN-OFF, AND PROVIDE SHADED AREAS

TREE SPECIES SELECTED FOR THEIR HIGH SALT TOLERANCE

ROW OF TALL PLANTED ON TOP OF BERM TO SCREEN VIEWS OF PARKING LOT AND UTILITIES FROM MEDICAL CLINIC

CONIFEROUS TREE PLANTING TO SCREEN UNWANTED VIEWS OF PARKING AND LOADING AREA

TREE PLANTING AROUND PROPOSED MEDICAL CLINIC TO HELP ENCOURAGE WILDLIFE, EVOKE SENSORY APPEAL, AND ENHANCE HUMAN HEALTH AND WELL-BEING

TREES PLANTED AROUND BUILDING HELP WITH STORM WATER RUNOFF, INFILTRATION, AND EROSION, PROVIDE SCREENING AND REDUCE BUILDING HEATING AND COOLING REQUIREMENTS, AND HAVE BEEN STRATEGICALLY PLACED TO REINFORCE THE IMPRESSION OF AN EXISTING LANDSCAPE

SMALL-CALIPER TREE WHIPS PLANTED IN LARGE GROUPINGS TO CREATE A NATURAL FOREST SETTING BETWEEN EXISTING FOREST AND NEW DEVELOPED AREA. ARBORETUM STYLE PLANTING CAN STILL BE ACHIEVED THROUGH DIVERSIFYING PLANT SPECIES AND INCORPORATING PLANT TAGS FOR EDUCATIONAL PURPOSES

UNDERSTOREY TREE PLANTING ON NORTH SIDE OF BUILDING TO ENHANCE NATURAL FOREST SETTING WHILE MAINTAINING CLEARANCE FROM ROOF CANOPY

VIEWS BETWEEN THE SUMMER STAFF HOUSING AND STAFF HOUSING TO BE MAINTAINED AND FRAMED

MINIMAL TRAIL DEVELOPMENT WITHIN CORE OF EXISTING FOREST

TREE PLANTING AROUND SEATING AND REST AREAS TO PROVIDE A NATURAL SOURCE OF SHADE, VISUAL INTEREST, AND ATTRACT ANIMAL SPECIES FOR OBSERVATION AND EDUCATION

ALLÉE OF DECIDUOUS TREE PLANTING FRAMES VIEWS ALONG TRAIL AND OUT TOWARDS THE LAKE. TREES PROVIDE SHADE WHILE ON THE TRAIL AND IN BETWEEN REST SPOTS. STRATEGIC TREE SPECIES SELECTED TO MINIMIZE DEBRIS ON TRAIL

NATIVE TREE SPECIES PROPOSED AROUND CAMPSITES TO REINFORCE A HEAVILY WOODED NATURALIZED SETTING, PROVIDE SCREENING BETWEEN CAMPSITES, AND ENHANCE A SENSE OF SECLUSION. PROPOSED PLANTING AROUND OFF GRID CABIN AND CAMPSITES TO INCLUDE PLANTS WITH MOSQUITO REPELLANT PROPERTIES

STRATEGIC TREE PLANTING TO CREATE LANDMARKS AND FOCAL POINTS

ROOTS OF MOISTURE TOLERANT TREES IMPROVE LONG TERM PERFORMANCE OF FILTER STRIPS

TREES TO PROVIDE SEPARATION BETWEEN SPACES, PRIVACY FROM WITHIN THE CAMPER BUILDINGS, AND COOLER TEMPERATURE MICROCLIMATE AROUND DECKS AND PORCHES


TREES WITH DEEP, FIBROUS ROOT SYSTEMS TO PROVIDE SLOPE STABILITY AND OFFER SHADED CANOPY ALONG PATHWAY

STRATEGIC TREE SPECIES TO PROVIDE DEEP, SPREADING, STRUCTURAL ROOTS WITH STRONG LATERAL ANCHORAGE


ACCENT TREE PLANTING TO CREATE INTEREST AND FOCAL POINT, PROVIDE SHADE, AND ENHANCE BIODIVERSITY WITHIN OPEN LAWN AREA

REFER TO L0.1 FOR NOTES AND LEGEND
REFER TO L2.1 FOR TREE PLANT MATERIAL SCHEDULE

0 15 30 100 150
SCALE: 1:1500

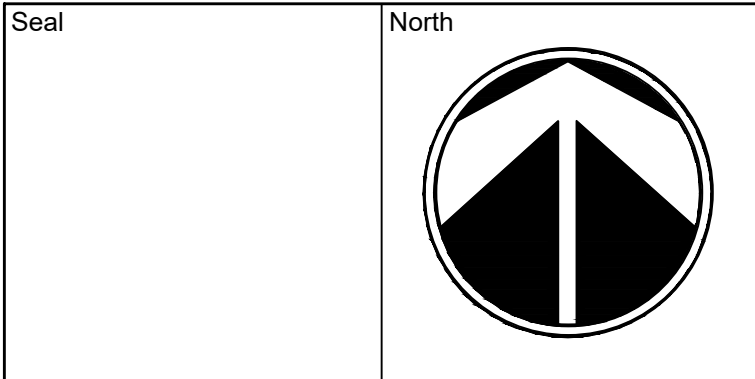

No.	Issues and Revisions	Date
1.	ISSUED FOR SPA	2025-08-15
2.	ISSUED FOR COORDINATION	2026-01-27
3.	REISSUED FOR SPA	2026-02-06
4.	REISSUED FOR COORDINATION	2026-07-28
5.	ISSUED FOR SPA - 3RD SUBMISSION	2026-08-18

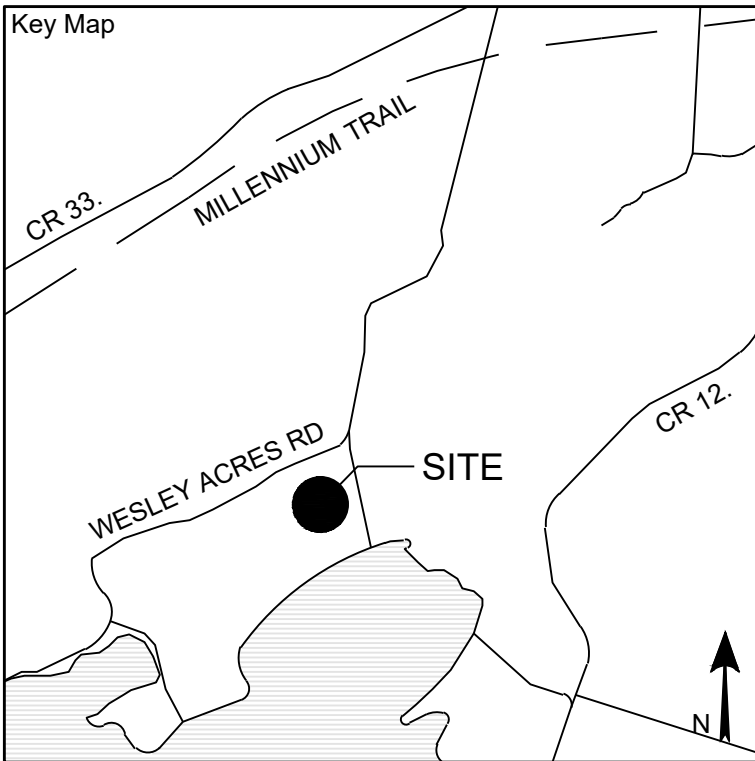

Project Notes
This design and drawing are the property of The Scott Wentworth Landscape Group Ltd. and are not to be copied or used for construction purposes without the Landscape Architect's express written consent.

The contractor shall check and verify all dimensions and report any discrepancies, error, or omissions to the Landscape Architect prior to commencing work.

Base plan information taken from Site Plan provided by:
Company Name:
Dated:

Wentworth Landscapes
13392 Loyalist Parkway R.R.1, Picton ON K0K 2T0
613.547.3772

Consultants



Client: CAMPFIRE CIRCLE	
Project: CAMPFIRE CIRCLE	
Project Location: 565 WESLEY ACRES ROAD BLOOMFIELD, ON	
Drawing Title: FOREST ENHANCEMENTS AND TREE PLANTING APPROACH	
Scale: 1:1500	
Date: 2025-06-25	Plot Date: 2026-08-18
Designed By: MH	Drawn By: PL/LT
Approved By: SW	Drawing Number: L2.0
Project Number: 23011-DC	

G:\Shared drives\Commercial Department\02 - PROJECTS\2023\23011-DC - Campfire Circle - SWSHEET SET\23011-DC - Campfire Circle - L2.1 - Wetland Enhancements.dwg

LEGEND


RIPARIAN NATIVE PLANT BUFFER

OPEN WATER CLEAR OF VEGETATION

INSECT RICH FISHING ZONE

NATURALIZED SHORELINE BUFFER


OPEN LAKE ACCESS POINT FOR RECREATIONAL ACTIVITIES

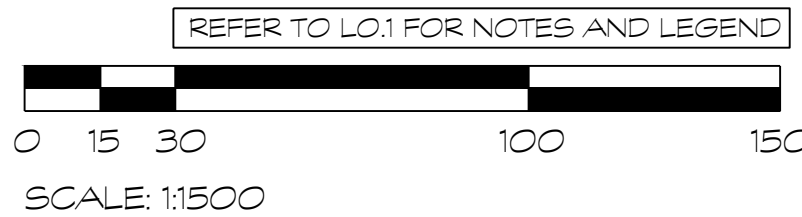

Seal

North

No.	Issues and Revisions	Date
1.	ISSUED FOR SPA	2025-08-15
2.	ISSUED FOR COORDINATION	2026-01-27
3.	REISSUED FOR SPA	2026-02-06
4.	REISSUED FOR COORDINATION	2026-07-28
5.	ISSUED FOR SPA - 3RD SUBMISSION	2026-08-18

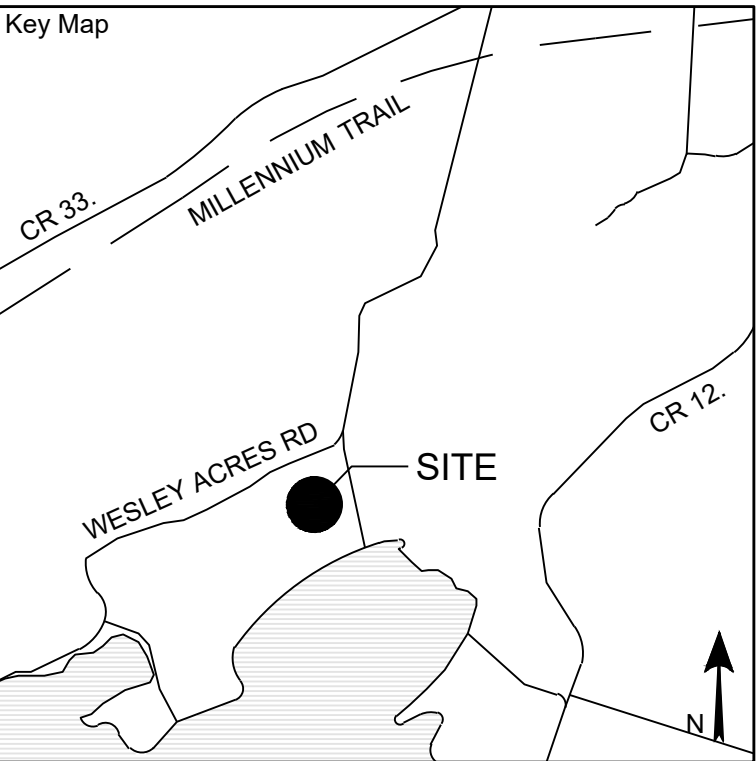

Project Notes

This design and drawing are the property of The Scott Wentworth Landscape Group Ltd. and are not to be copied or used for construction purposes without the Landscape Architect's express written consent.

The contractor shall check and verify all dimensions and report any discrepancies, error, or omissions to the Landscape Architect prior to commencing work.

Base plan information taken from Site Plan provided by:
Company Name:
Dated:





Wentworth Landscapes
13392 Loyalist Parkway R.R.1, Picton ON K0K 2T0
613.547.3772

Consultants



Client CAMPFIRE CIRCLE	
Project CAMPFIRE CIRCLE	
Project Location 565 WESLEY ACRES ROAD BLOOMFIELD, ON	
Drawing Title WETLAND ENHANCEMENTS	
Scale 1:1500	
Date 2025-06-25	Plot Date 2026-08-18
Designed By MH	Drawn By PL/LT
Approved By SW	Drawing Number
Project Number 23011-DC	L2.1

    G:\Shared drives\Commercial Department\02 - PROJECTS\2023\23011-DC - Campfire Circle - SWSHEET SET\23011-DC - Campfire Circle - L2.2 - Meadow Grassland Enhancements.dwg

LEGEND			
	SEED MIX 1 GRAHAM TURF SEEDS LTD. OPTI PASTURE MIX		SEED MIX 4 OSC MEDIUM HEIGHT PRAIRIE GRASS NATIVE SEED MIX 8130
	SEED MIX 2 OSC LOW MAINTENANCE RETENTION BASIN SEED MIX 8220		SEED MIX 5 OSC SLOPE AND HILLSIDE NATIVE SEED MIX 8225
	SEED MIX 3 WILLIAMS NURSERY AND ECOLOGY CENTRE TALLGRASS PRAIRIE SEED MIX		RIPARIAN ENHANCEMENT ZONE

SEED MIX 1
GRAHAM TURF SEEDS LTD.
OPTI PASTURE MIX FOR HORSE PASTURE AREA
CONTAINING: ANJO TIMOTHY, SHOCKWAVE BR ALFALFA, ARSENAL MEADOW BROME,
BRONSON SL TALL FESCUE, SORAYA PERENNIAL RYEGRASS,
KAKARIKI LADINO WHITE CLOVER, AND HUJA WHITE CLOVER.



SEED MIX 2
OSC LOW MAINTENANCE RETENTION BASIN NATIVE SEED MIXTURE
CONTAINING: POA PALUSTRIS, CAREX VULPINOIDEA, AND ELYMUS VIGINICUS.

SEED MIX 3
ST. WILLIAMS NURSERY AND ECOLOGY CENTRE
TALLGRASS PRAIRIE SEED MIX
CONTAINING: SORGHASTRUM NUTANS,
ANDROPOGON GERARDII, PANICUM VIRGATUM,
ELYMUS VIRGINICUS, ELYMUS CANADENSIS,
SCHIZACHYRIUM SCOPARIUM, OENOTHERA
BIENNIS, PENSTEMON DIGITALIS, RUDBECKIA
HIRTA, LESPEDEZA CAPITATA, CEANOTHUS
AMERICANUS, DESMODIUM CANADENSE,
SOLIDAGO PTARMICOIDES, PENSTEMON
HIRSUTUS, DOELLINGERIA UMBELLATA,
DESMODIUM PANICULATUM, SPOROBOLUS
CRYPTANDRUS, PYCNANTHEMUM VIRGINIANUM,
POTENTILLA ARGUTA, SOLIDAGO NYMPHEALIS,
RATIBIDA PINNATA, COREOPSIS TRIPTERIS,
SYMPHYOTRICHUM LAEVE, SOLIDAGO RIGIDA,
GEUM TRIFLORUM, EUPATORIUM MACULATUM,
MONARDA FISTULOSA, SOLIDAGO JUNCEA,
LIATRIS SPICATA, SILPHIUM TEREBINTHACEUM,
ELYMUS TRACHYCAULUS, BOUTELOUA
CURTIPENDULA, ECHINACEA PALLIDA, LESPEDEZA
HIRTA, MONARDA PUNCTATA, AND
PYCNANTHEMUM TENUIFOLIUM


SEED MIX 4
OSC MEDIUM HEIGHT PRAIRIE GRASS
NATIVE SEED MIXTURE
CONTAINING: ANDROPOGON GERARDII,
SORGHASTRUM NUTANS, SCHIZACHYRIUM
SCOPARIUM, SPARTINA PECTINATA,
PANICUM VIRGATUM.

SEED MIX 5
OSC SLOPE AND HILLSIDE NATIVE SEED MIX 8225
CONTAINING: AGROSTIS PERENNANS, RUDBECKIA
HIRTA, ELYMUS HYSTRIX, SCHIZACHYRIUM
SCOPARIUM, ASTER NOVAE-ANGLIAE, AVENA
SATIVA, MONARDA FISTULOSA

WEST LAKE

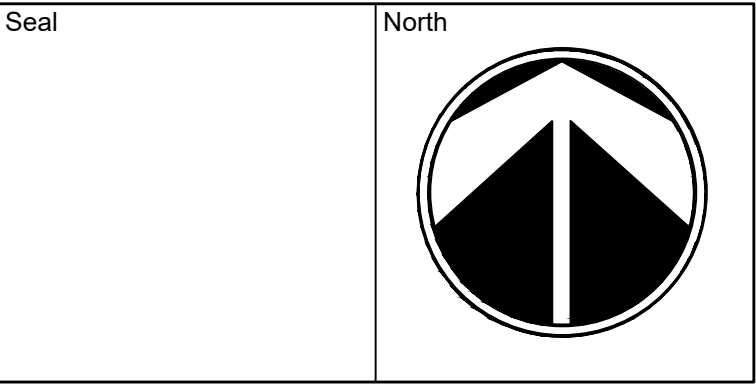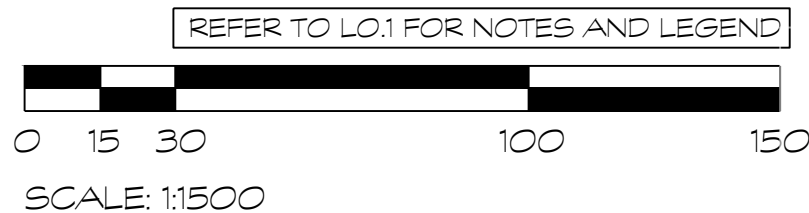

No.	Issues and Revisions	Date
1.	ISSUED FOR SPA	2025-08-15
2.	ISSUED FOR COORDINATION	2026-01-27
3.	REISSUED FOR SPA	2026-02-06
4.	REISSUED FOR COORDINATION	2026-07-28
5.	ISSUED FOR SPA - 3RD SUBMISSION	2026-08-18

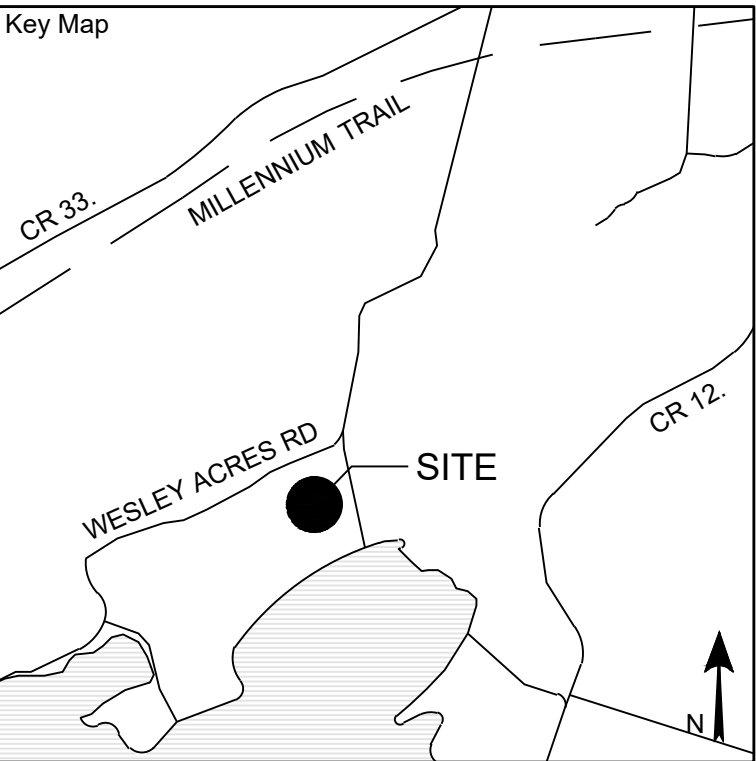

Project Notes
This design and drawing are the property of The Scott Wentworth Landscape Group Ltd. and are not to be copied or used for construction purposes without the Landscape Architect's express written consent.

The contractor shall check and verify all dimensions and report any discrepancies, error, or omissions to the Landscape Architect prior to commencing work.

Base plan information taken from Site Plan provided by:
Company Name:
Dated:

Wentworth Landscapes
13392 Loyalist Parkway R.R.1, Picton ON K0K 2T0
613.547.3772

Consultants



Client CAMPFIRE CIRCLE	
Project CAMPFIRE CIRCLE	
Project Location 565 WESLEY ACRES ROAD BLOOMFIELD, ON	
Drawing Title MEADOW/GRASSLAND ENHANCEMENTS	
Scale 1:1500	
Date 2025-06-25	Plot Date 2026-08-18
Designed By MH	Drawn By PL/LT
Approved By SW	Drawing Number
Project Number 23011-DC	L2.2

G:\Shared drives\Commercial Department\02 - PROJECTS\2023\23011-DC - Campfire Circle - SWSHEET SET\23011-DC - Campfire Circle - L2.3 - Vegetative Screening.dwg

LEGEND

PROPOSED VEGETATIVE SCREENING



REFER TO L01 FOR NOTES AND LEGEND


01530100150

SCALE: 1:1500

Seal

North

No.	Issues and Revisions	Date
1.	ISSUED FOR SPA	2025-08-15
2.	ISSUED FOR COORDINATION	2026-01-27
3.	REISSUED FOR SPA	2026-02-06
4.	REISSUED FOR COORDINATION	2026-07-28
5.	ISSUED FOR SPA - 3RD SUBMISSION	2026-08-18

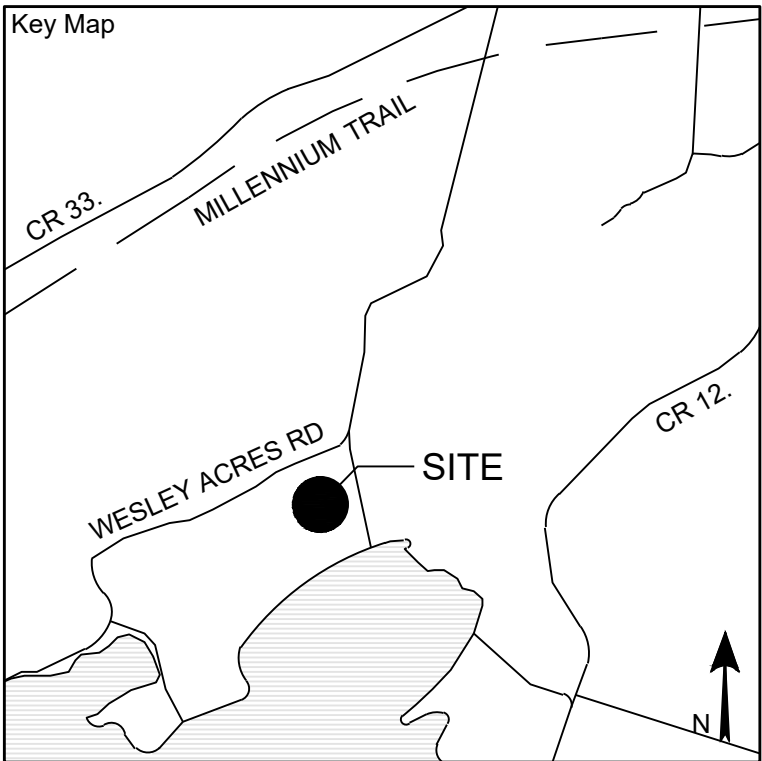

Project Notes

This design and drawing are the property of The Scott Wentworth Landscape Group Ltd. and are not to be copied or used for construction purposes without the Landscape Architect's express written consent.

The contractor shall check and verify all dimensions and report any discrepancies, error, or omissions to the Landscape Architect prior to commencing work.

Base plan information taken from Site Plan provided by:
Company Name:
Dated:

Wentworth Landscapes
13392 Loyalist Parkway R.R.1, Picton ON K0K 2T0
613.547.3772

Consultants



Client

CAMPFIRE CIRCLE

Project

CAMPFIRE CIRCLE

Project Location

565 WESLEY ACRES ROAD
BLOOMFIELD, ON

Drawing Title

VEGETATIVE SCREENING

Scale

1:1500

Date

2025-06-25

Plot Date

2026-08-18

Designed By

MH

Drawn By

PL/LT

Approved By

SW

Drawing Number

Project Number

23011-DC

L2.3

G:\Shared drives\Commercial Department\02 - PROJECTS\2023\23011-DC - Campfire Circle - SWSHEET SET\23011-DC - Campfire Circle - L2.4 - Stormwater Management.dwg

LEGEND

PROPOSED STORMWATER
MITIGATION PLANTING AREAS



SALT TOLERANT VEGETATIVE FILTER STRIPS IMMEDIATELY ADJACENT TO PARKING LOTS AND BETWEEN ROWS OF STALLS HELP TREAT STORMWATER RUNOFF, ESPECIALLY POLLUTANTS FROM VEHICLES, AND ACTS AS A FIRST PASS OF TREATMENT BEFORE STORMWATER CONTINUES TO FLOW THROUGH THE SITE

NATURALIZED PLANTING BEDS AROUND BUILDINGS MITIGATES WATER RUN-OFF FROM ROOFTOP SHEET DRAINAGE AND DOWNSPOUTS

OPEN SODDED LAWN ACTS AS A PERMEABLE SURFACE, RETAINING WATER ON SITE AND REDUCING RUNOFF

RAINGARDEN FEATURE PLANTING AREA ACTS AS A FUNCTIONAL EDUCATIONAL TOOL SHOWCASING THE IMPORTANCE OF BIODIVERSITY AND SUSTAINABLE PLANTING DESIGN

VEGETATIVE FILTER STRIP PLANTING BEDS ALONG ANY HARDSCAPED AREAS SUCH AS PATHWAYS AND ROADWAYS TO HELP SLOW DOWN, REDUCE, AND FILTER STORMWATER RUNOFF BEFORE IT REACHES THE LAKE AND PROVIDES LONG-TERM SLOPE STABILITY

DEEP ROOTING TREES NEAR SHORELINE TO MAXIMIZE SOIL INFILTRATION CAPACITY AND IMPROVE SOIL STABILITY

WEST LAKE

REFER TO L0.1 FOR NOTES AND LEGEND


01530100150

SCALE: 1:1500

Seal

North

No.	Issues and Revisions	Date
1.	ISSUED FOR SPA	2025-08-15
2.	ISSUED FOR COORDINATION	2026-01-27
3.	REISSUED FOR SPA	2026-02-06
4.	REISSUED FOR COORDINATION	2026-07-28
5.	ISSUED FOR SPA - 3RD SUBMISSION	2026-08-18

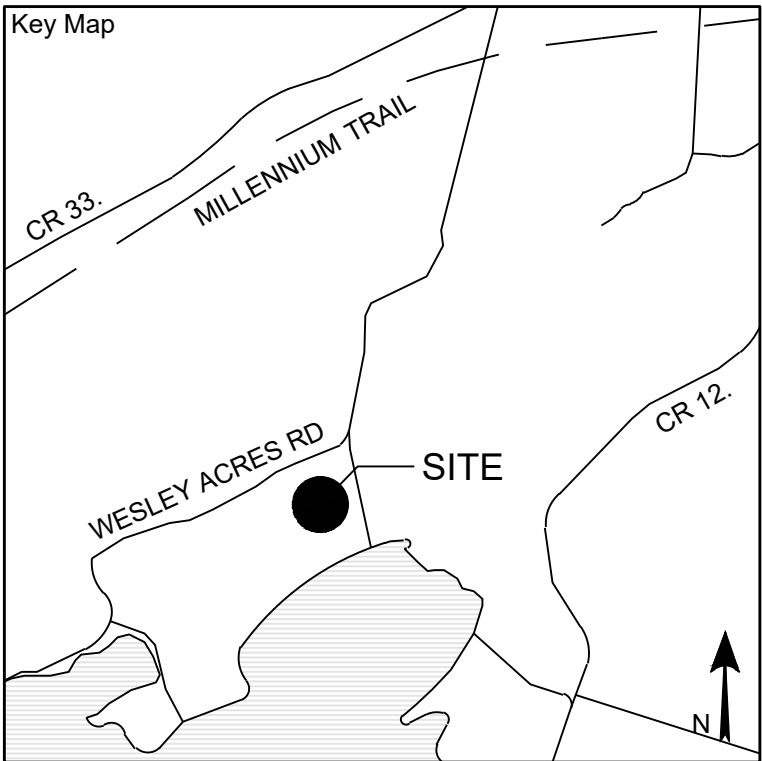

Project Notes

This design and drawing are the property of The Scott Wentworth Landscape Group Ltd. and are not to be copied or used for construction purposes without the Landscape Architect's express written consent.

The contractor shall check and verify all dimensions and report any discrepancies, error, or omissions to the Landscape Architect prior to commencing work.

Base plan information taken from Site Plan provided by:
Company Name:
Dated:

Wentworth Landscapes
13392 Loyalist Parkway R.R.1, Picton ON K0K 2T0
613.547.3772

Consultants




Client CAMPFIRE CIRCLE	
Project CAMPFIRE CIRCLE	
Project Location 565 WESLEY ACRES ROAD BLOOMFIELD, ON	
Drawing Title STORMWATER MANAGEMENT	
Scale 1:1500	
Date 2025-06-25	Plot Date 2026-08-18
Designed By MH	Drawn By PL/LT
Approved By SW	Drawing Number
Project Number 23011-DC	L2.4

G:\Shared drives\Commercial Department\02 - PROJECTS\2023\23011-DC - Campfire Circle - SWSHEET SET\23011-DC - Campfire Circle - L2.5 - Species Habitat Enhancements.dwg

LEGEND


PROPOSED ENHANCED HABITAT FOR SPECIAL STATUS SPECIES

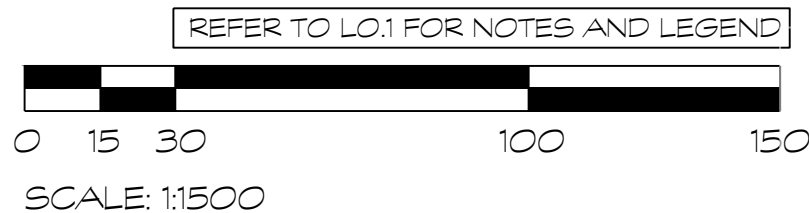

Seal

North

No.	Issues and Revisions	Date
1.	ISSUED FOR SPA	2025-08-15
2.	ISSUED FOR COORDINATION	2026-01-27
3.	REISSUED FOR SPA	2026-02-06
4.	REISSUED FOR COORDINATION	2026-07-28
5.	ISSUED FOR SPA - 3RD SUBMISSION	2026-08-18

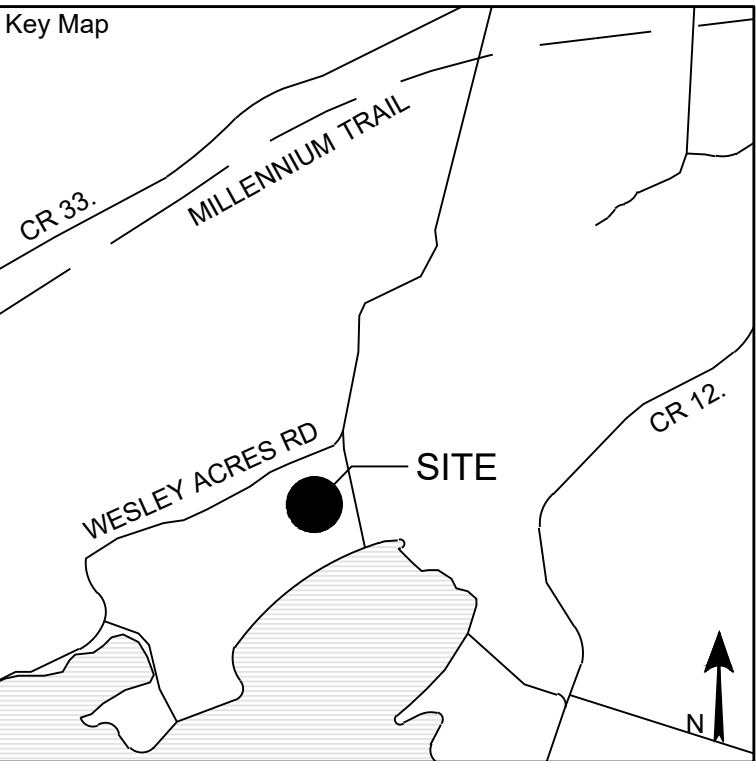

Project Notes

This design and drawing are the property of The Scott Wentworth Landscape Group Ltd. and are not to be copied or used for construction purposes without the Landscape Architect's express written consent.

The contractor shall check and verify all dimensions and report any discrepancies, error, or omissions to the Landscape Architect prior to commencing work.

Base plan information taken from Site Plan provided by:
Company Name:
Dated:

Wentworth Landscapes
13392 Loyalist Parkway R.R.1, Picton ON K0K 2T0
613.547.3772

Consultants



Client

CAMPFIRE CIRCLE

Project

CAMPFIRE CIRCLE

Project Location

565 WESLEY ACRES ROAD
BLOOMFIELD, ON

Drawing Title

SPECIES HABITAT ENHANCEMENTS

Scale

1:1500

Date

2025-06-25

Designed By

MH

Approved By

SW

Project Number

23011-DC

Plot Date

2026-08-18

Drawn By

PL/LT

Drawing Number

L2.5


G:\Shared drives\Commercial Department\02 - PROJECTS\2023\23011-DC - Campfire Circle - SWSHEET SET\23011-DC - Campfire Circle - L3.0 - Key Plan.dwg



Seal

North

No.	Issues and Revisions	Date
1.	ISSUED FOR SPA	2025-08-15
2.	ISSUED FOR COORDINATION	2026-01-27
3.	REISSUED FOR SPA	2026-02-06
4.	REISSUED FOR COORDINATION	2026-07-28
5.	ISSUED FOR SPA - 3RD SUBMISSION	2026-08-18

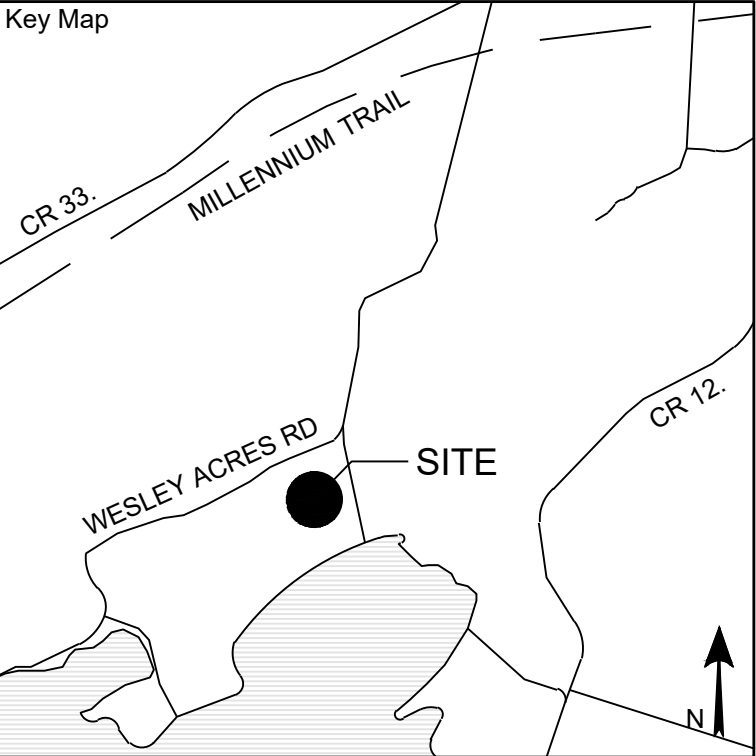

Project Notes

This design and drawing are the property of The Scott Wentworth Landscape Group Ltd. and are not to be copied or used for construction purposes without the Landscape Architect's express written consent.

The contractor shall check and verify all dimensions and report any discrepancies, error, or omissions to the Landscape Architect prior to commencing work.

Base plan information taken from Site Plan provided by:
Company Name:
Dated:



Wentworth Landscapes
13392 Loyalist Parkway R.R.1, Picton ON K0K 2T0
613.547.3772

Consultants




Client CAMPFIRE CIRCLE	
Project CAMPFIRE CIRCLE	
Project Location 565 WESLEY ACRES ROAD BLOOMFIELD, ON	
Drawing Title LANDSCAPE ENLARGEMENTS KEY PLAN	
Scale 1:1500	
Date 2025-06-25	Plot Date 2026-08-18
Designed By MH	Drawn By PL/LT
Approved By SW	Drawing Number
Project Number 23011-DC	L3.0

G:\Shared drives\Commercial Department\02 - PROJECTS\2023\23011-DC - Campfire Circle - SWSHEET SET\23011-DC - Campfire Circle - L3.1 - Enlargement Plan 1.dwg

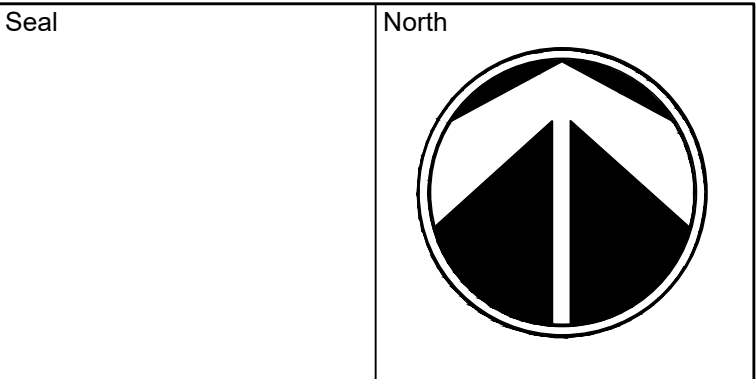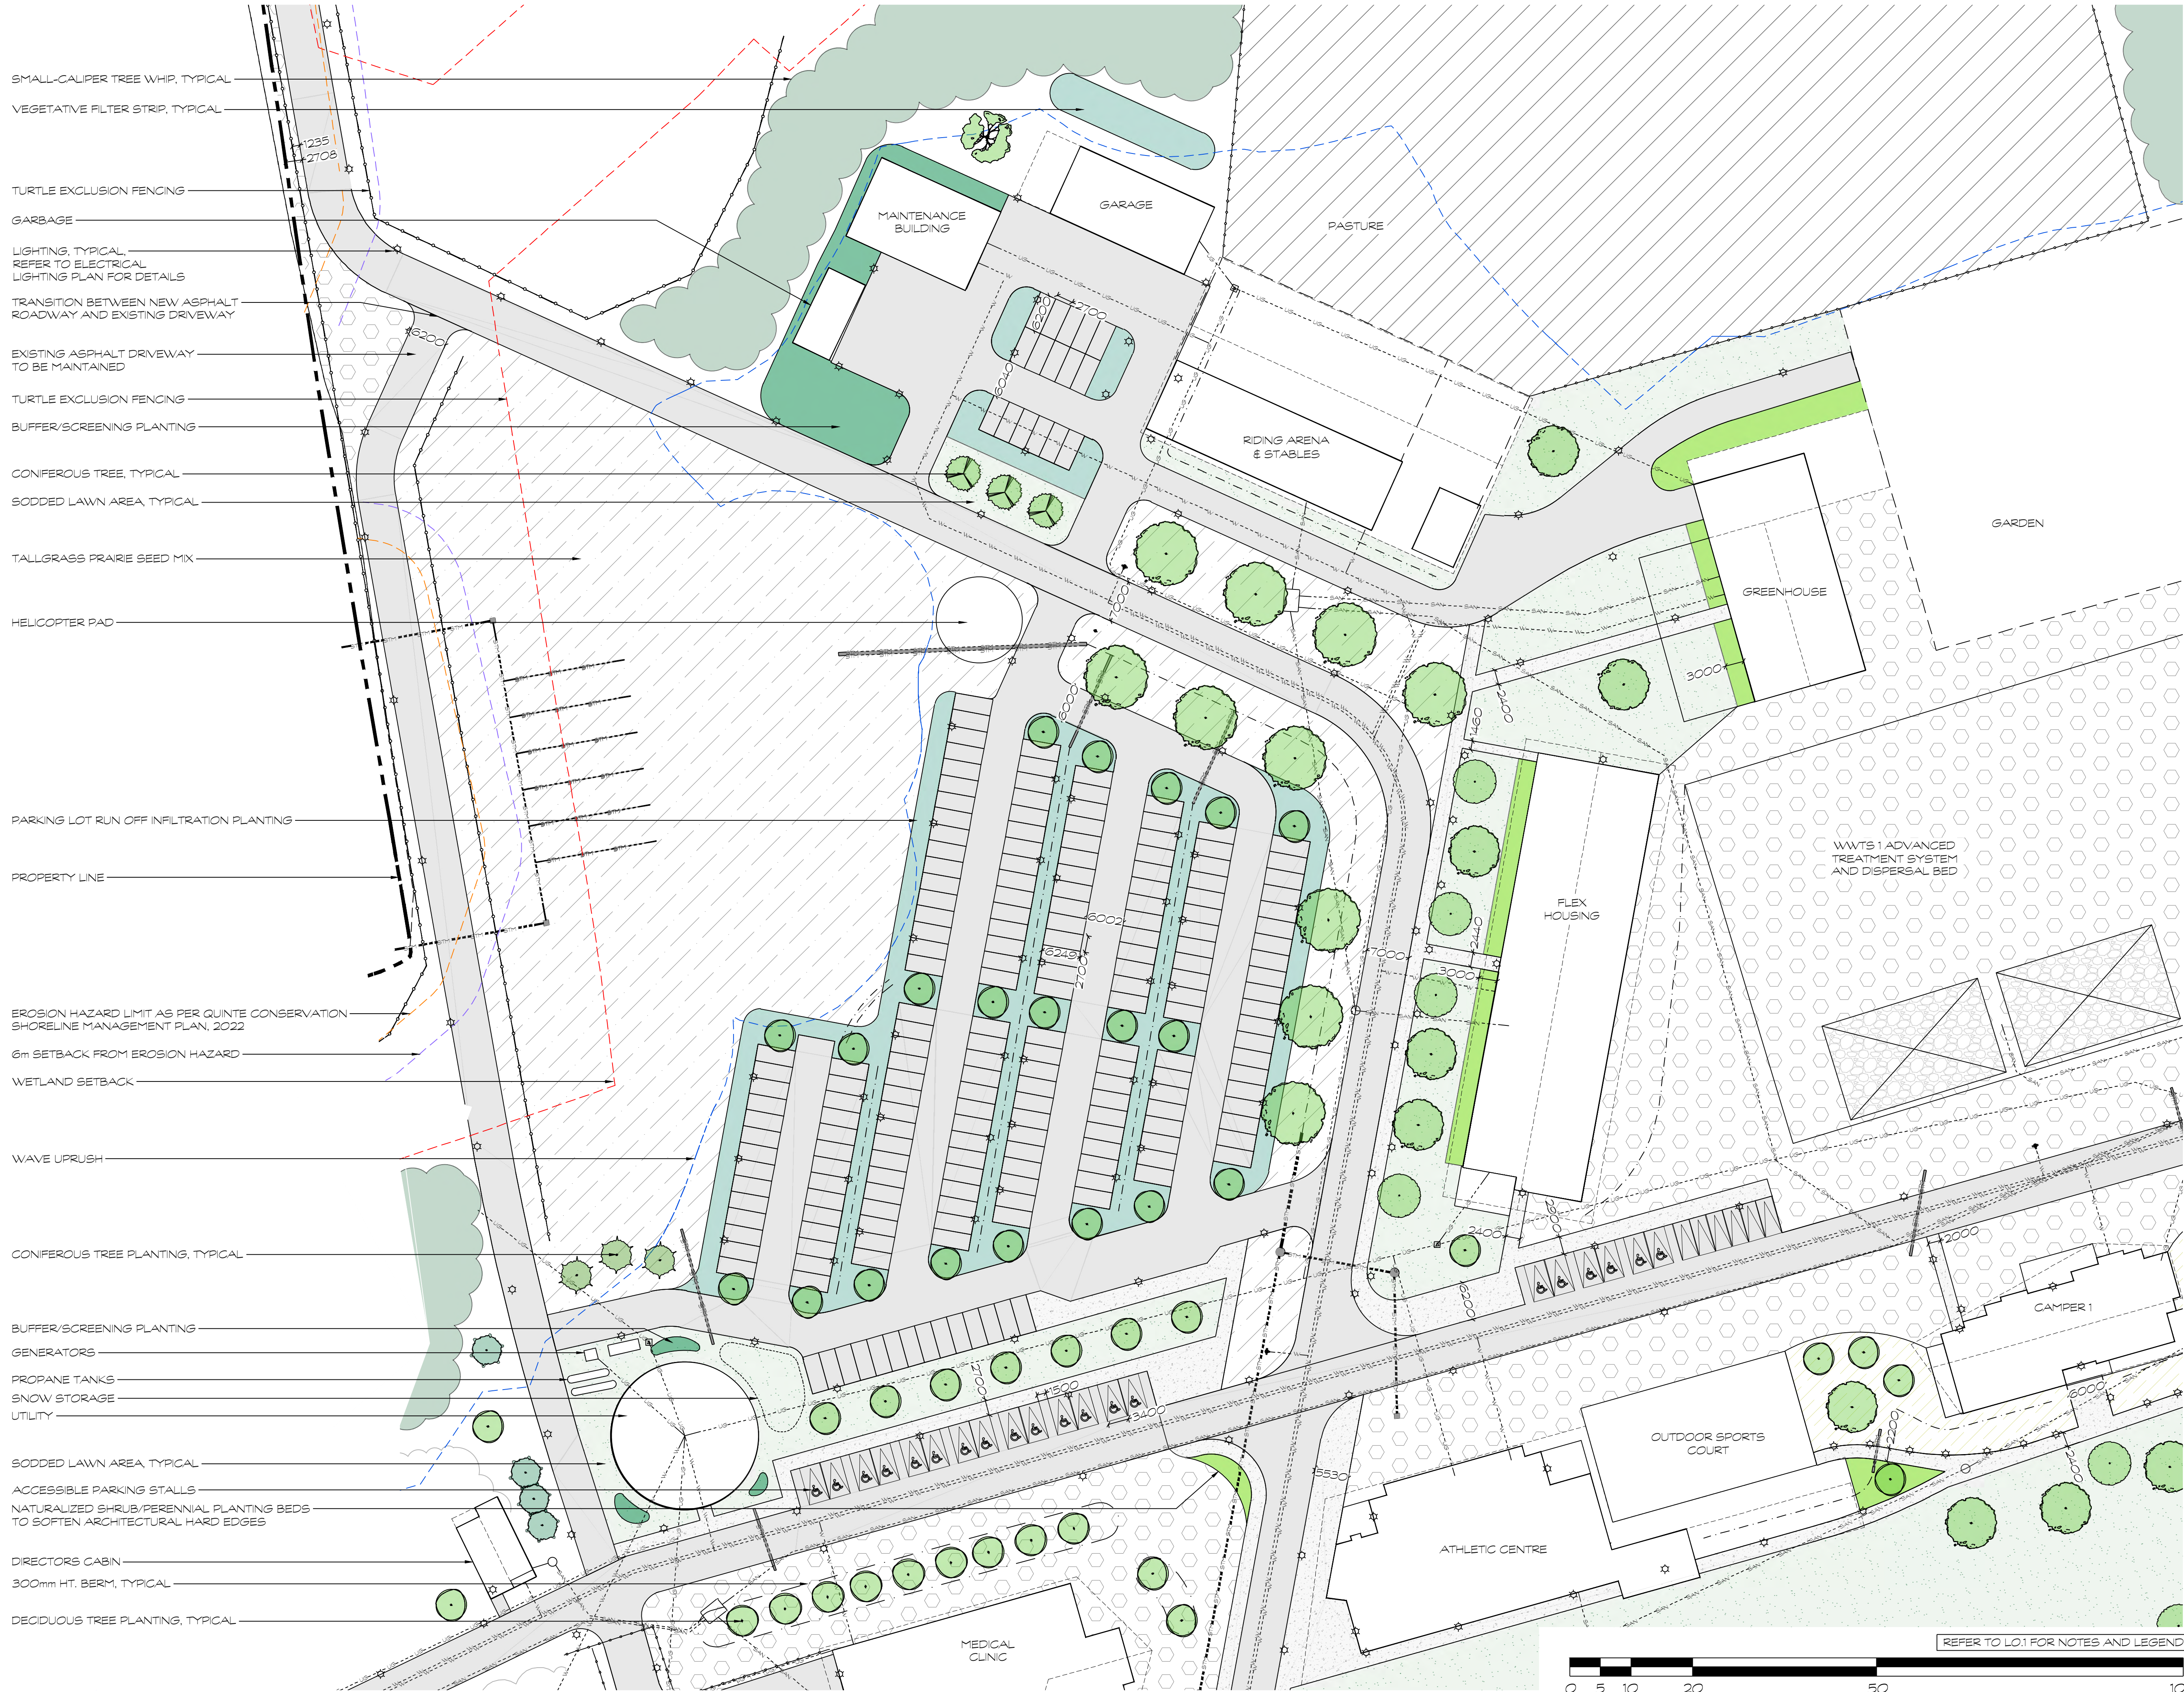

No.	Issues and Revisions	Date
1.	ISSUED FOR SPA	2025-08-15
2.	ISSUED FOR COORDINATION	2026-01-27
3.	REISSUED FOR SPA	2026-02-06
4.	REISSUED FOR COORDINATION	2026-07-28
5.	ISSUED FOR SPA - 3RD SUBMISSION	2026-08-18

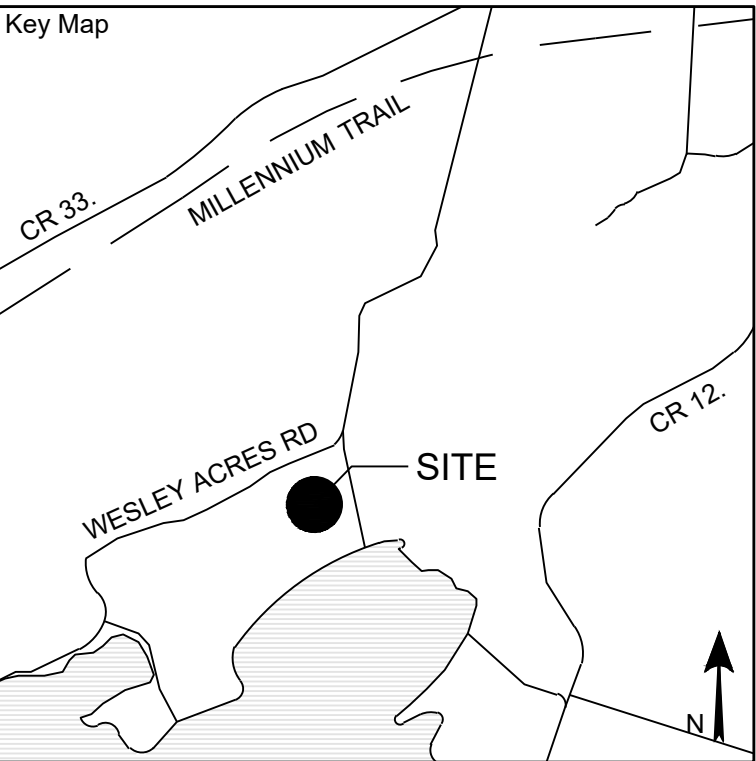

Project Notes

This design and drawing are the property of The Scott Wentworth Landscape Group Ltd. and are not to be copied or used for construction purposes without the Landscape Architect's express written consent.

The contractor shall check and verify all dimensions and report any discrepancies, error, or omissions to the Landscape Architect prior to commencing work.

Base plan information taken from Site Plan provided by:
Company Name:
Dated:


Wentworth Landscapes
13392 Loyalist Parkway R.R.1, Picton ON K0K 2T0
613.547.3772

Consultants



Client	CAMPFIRE CIRCLE
Project	CAMPFIRE CIRCLE
Project Location	565 WESLEY ACRES ROAD BLOOMFIELD, ON
Drawing Title	LANDSCAPE ENLARGEMENT PLAN (1 OF 4)
Scale	1:500
Date	2025-06-25
Designed By	MH
Approved By	SW
Project Number	23011-DC
Plot Date	2026-08-18
Drawn By	PL/LT
Drawing Number	L3.1


G:\Shared drives\Commercial Department\02 - PROJECTS\2023\23011-DC - Campfire Circle - SW\SHEET SET\23011-DC - Campfire Circle - L3.2 - Enlargement Plan 2.dwg

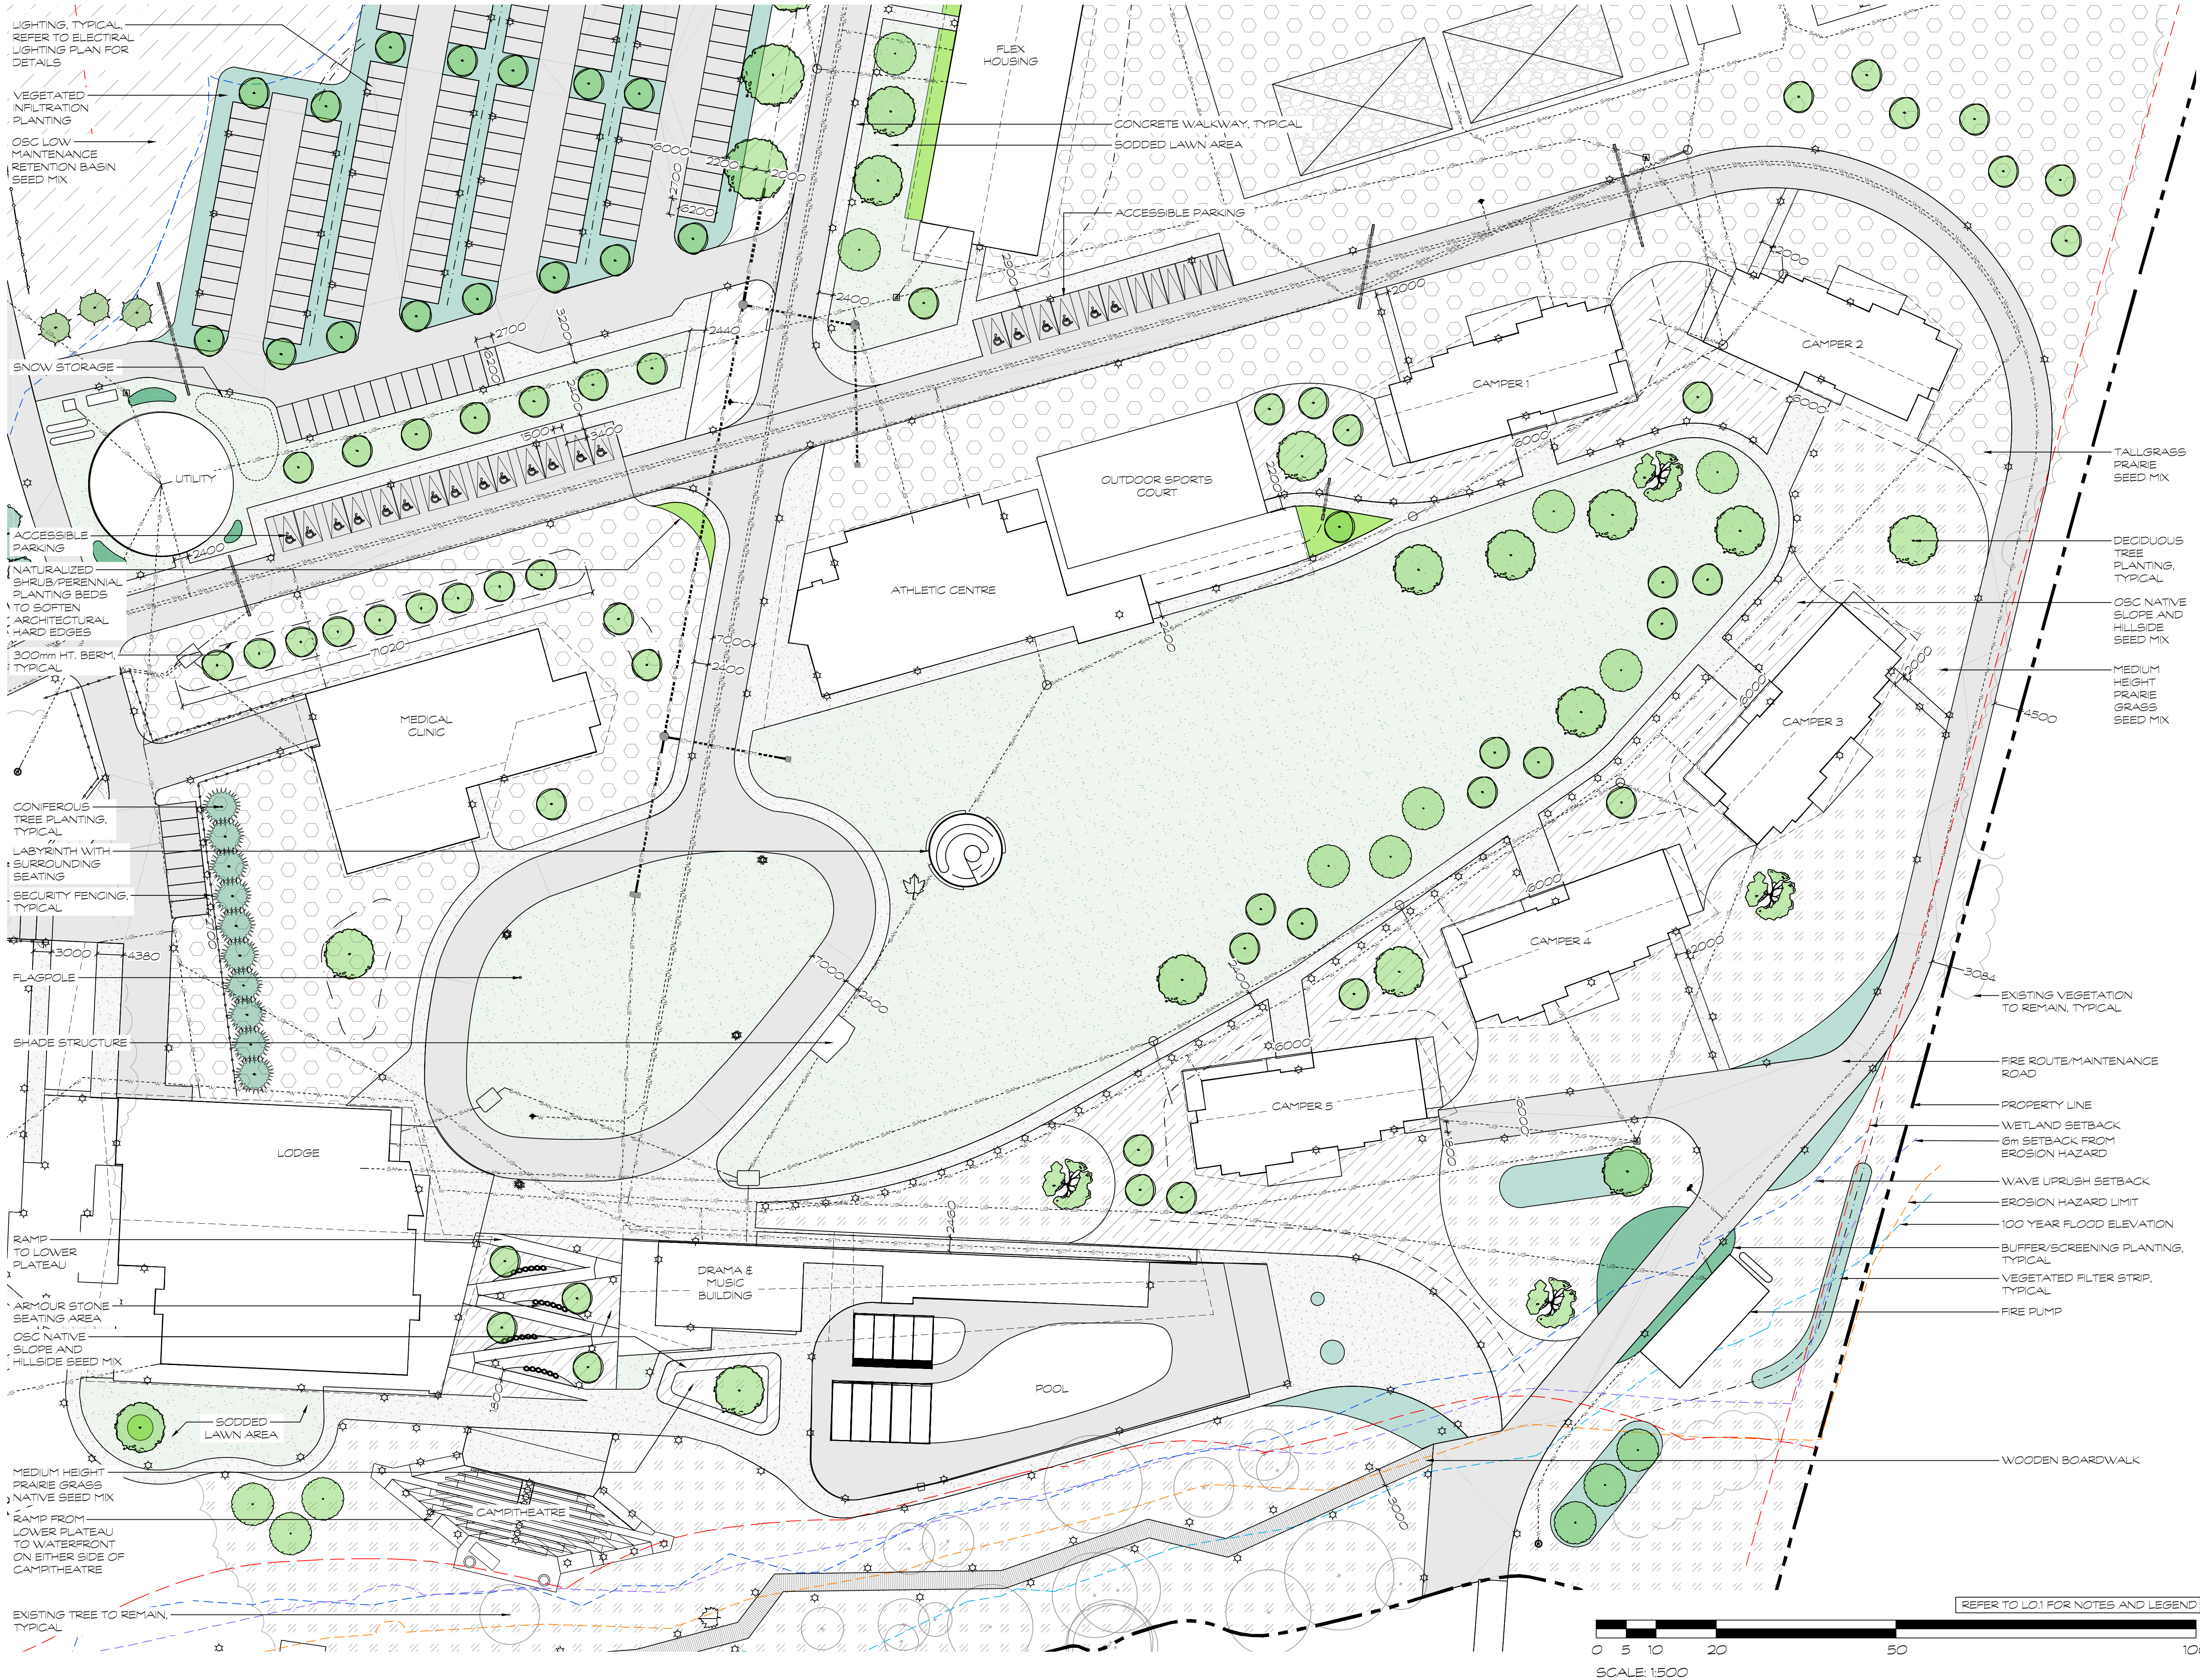

Seal

North

No.	Issues and Revisions	Date
1.	ISSUED FOR SPA	2025-08-15
2.	ISSUED FOR COORDINATION	2026-01-27
3.	REISSUED FOR SPA	2026-02-06
4.	REISSUED FOR COORDINATION	2026-07-28
5.	ISSUED FOR SPA - 3RD SUBMISSION	2026-08-18

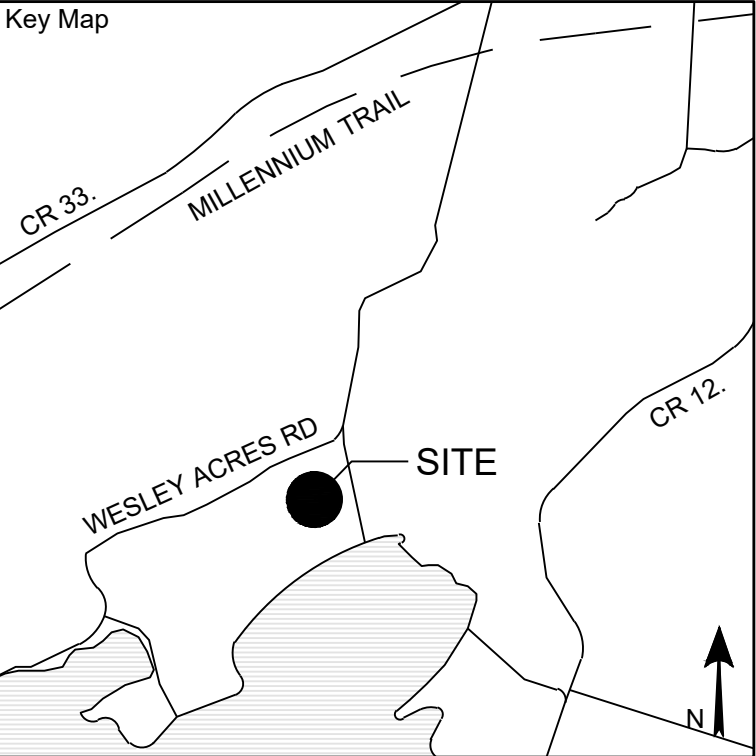

Project Notes
This design and drawing are the property of The Scott Wentworth Landscape Group Ltd. and are not to be copied or used for construction purposes without the Landscape Architect's express written consent.

The contractor shall check and verify all dimensions and report any discrepancies, error, or omissions to the Landscape Architect prior to commencing work.

Base plan information taken from Site Plan provided by:
Company Name:
Dated:



Wentworth Landscapes
13392 Loyalist Parkway R.R.1, Picton ON K0K 2T0
613.547.3772

Consultants




Client CAMPFIRE CIRCLE	
Project CAMPFIRE CIRCLE	
Project Location 565 WESLEY ACRES ROAD BLOOMFIELD, ON	
Drawing Title LANDSCAPE ENLARGEMENT PLAN (2 OF 4)	
Scale 1:500	
Date 2025-06-25	Plot Date 2026-08-18
Designed By MH	Drawn By PL/LT
Approved By SW	Drawing Number
Project Number 23011-DC	L3.2

G:\Shared drives\Commercial Department\02 - PROJECTS\2023\23011-DC - Campfire Circle - SW\Sheet SET\23011-DC - Campfire Circle - L3.3 - Enlargement Plan 3.dwg

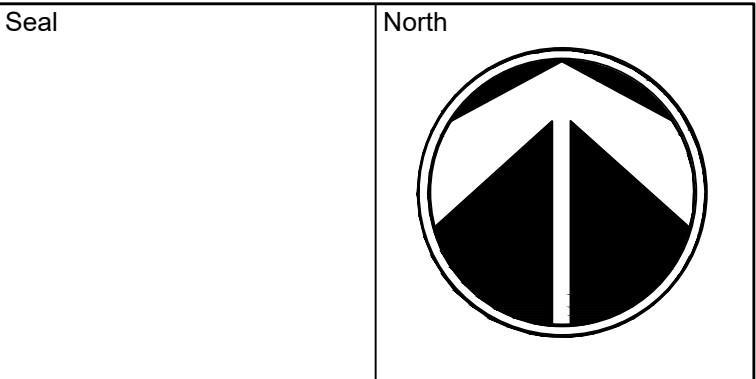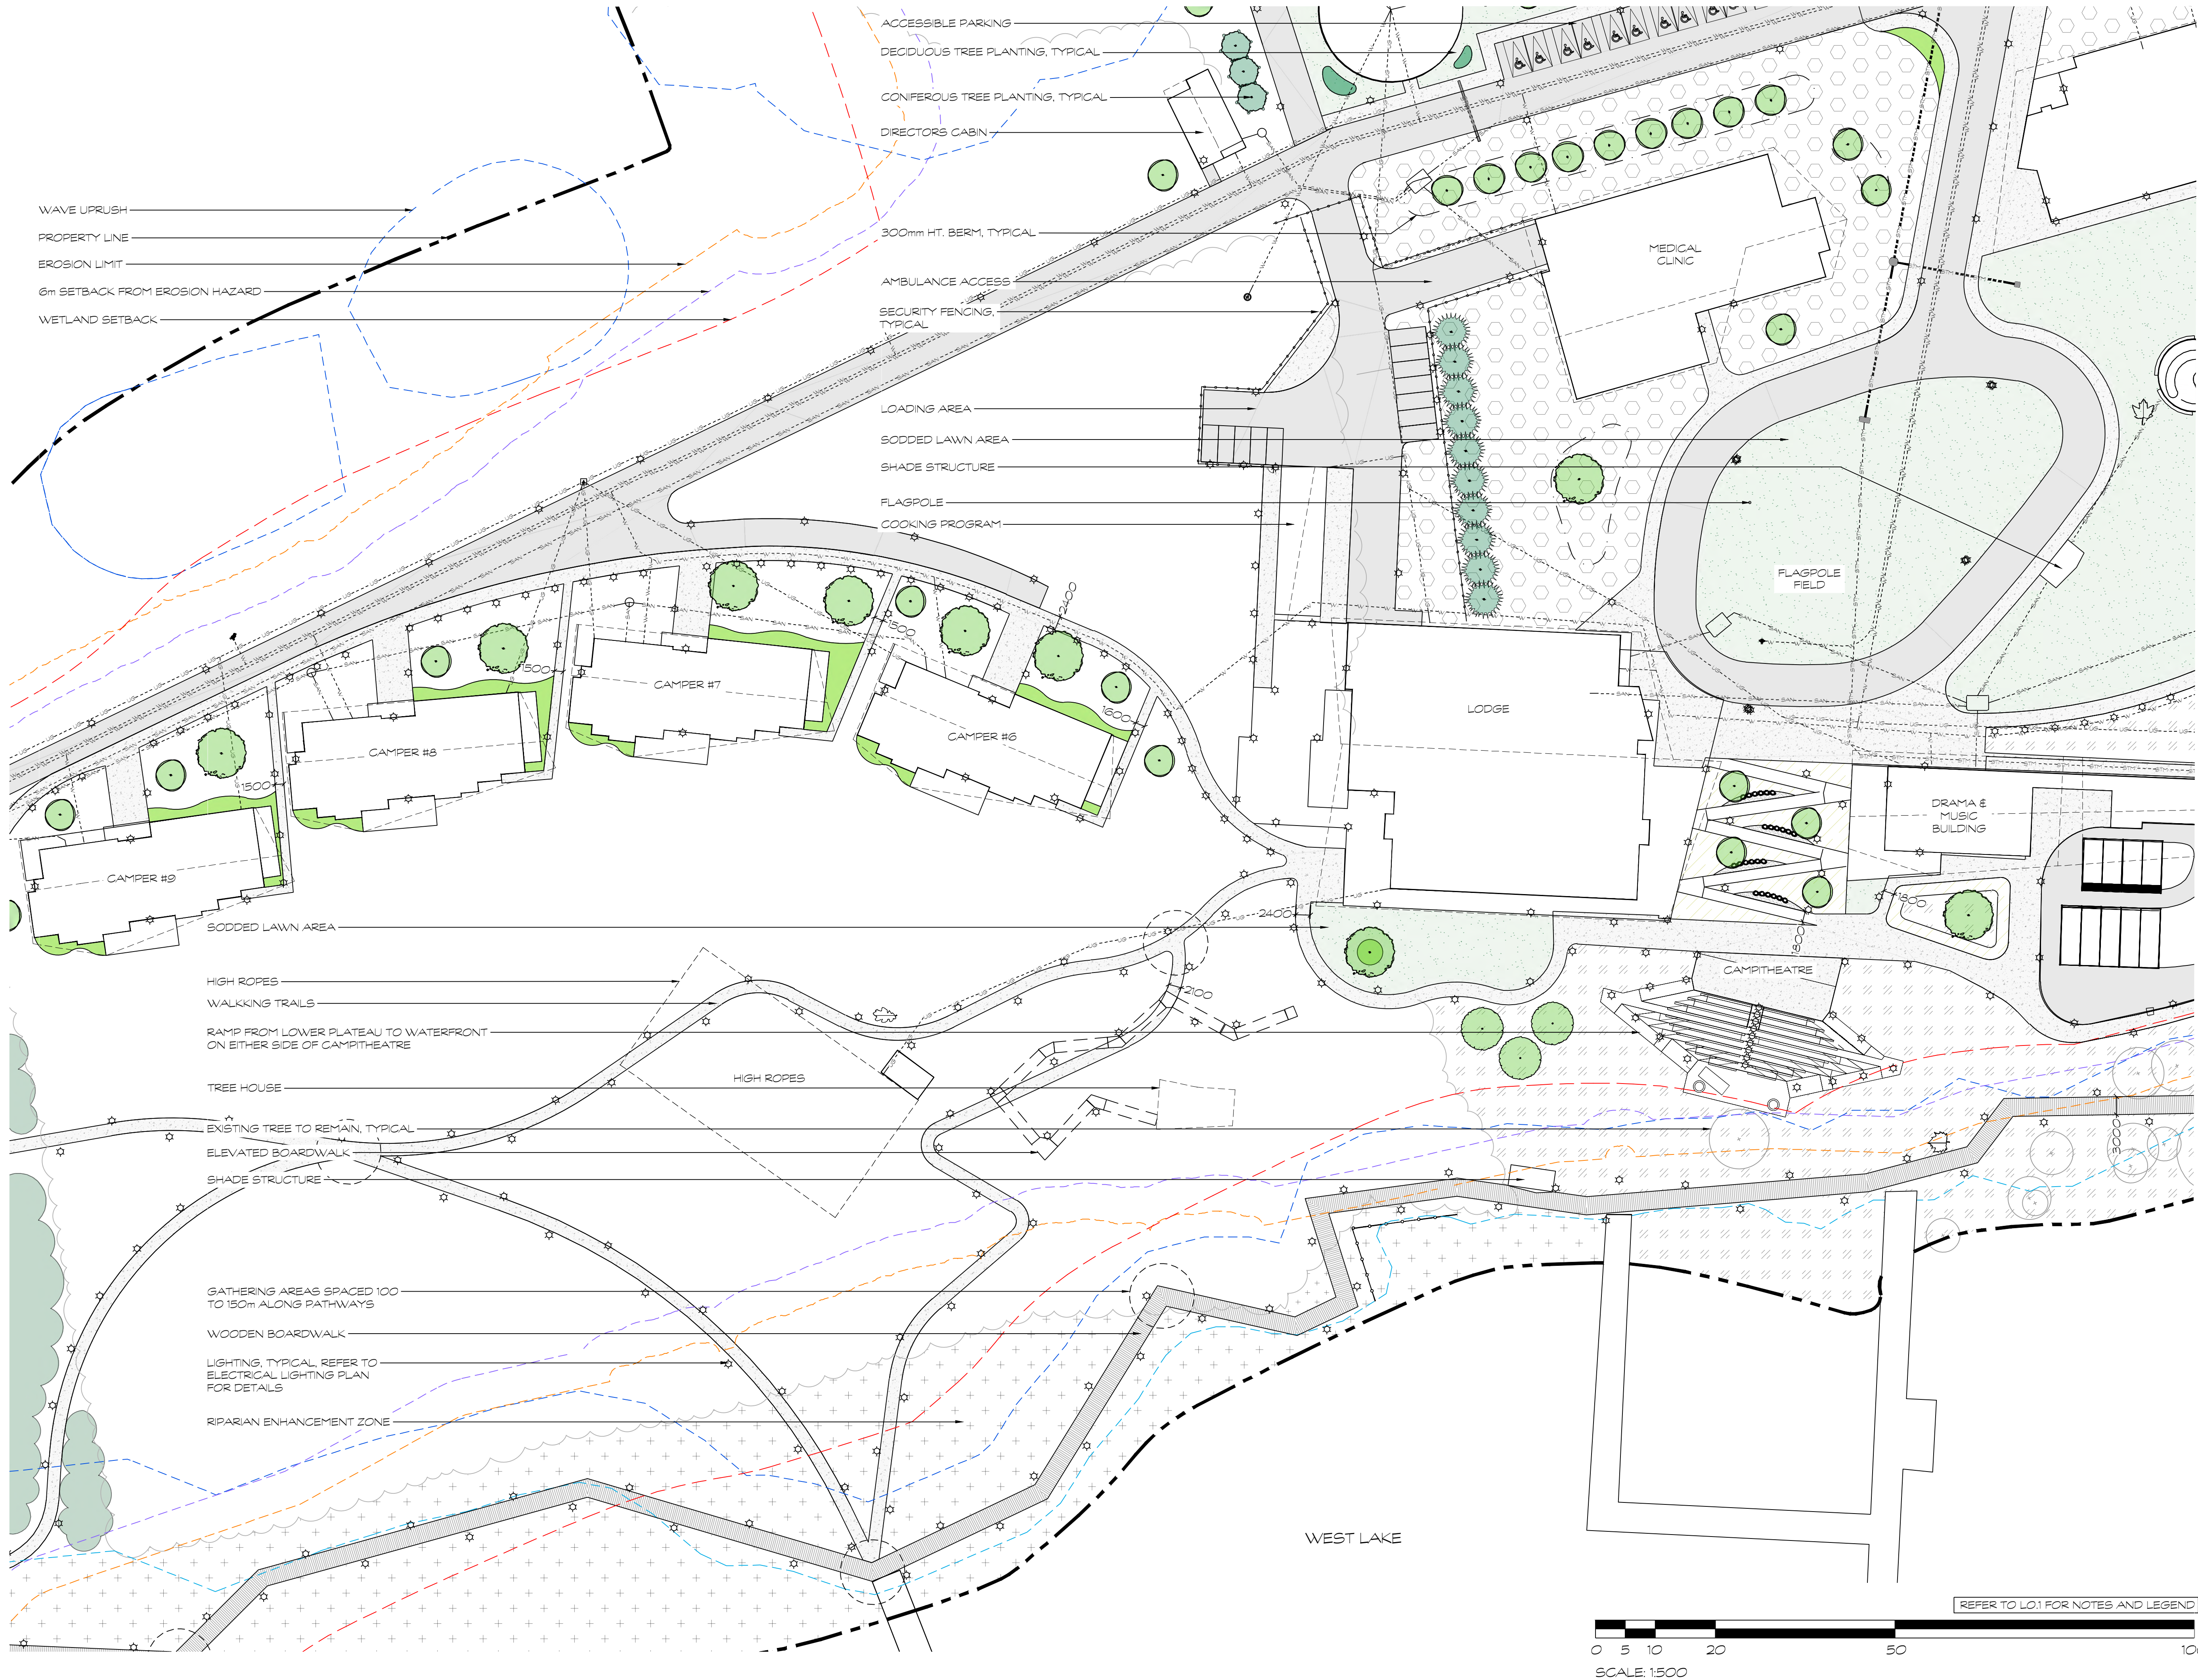

No.	Issues and Revisions	Date
1.	ISSUED FOR SPA	2025-08-15
2.	ISSUED FOR COORDINATION	2026-01-27
3.	REISSUED FOR SPA	2026-02-06
4.	REISSUED FOR COORDINATION	2026-07-28
5.	ISSUED FOR SPA - 3RD SUBMISSION	2026-08-18

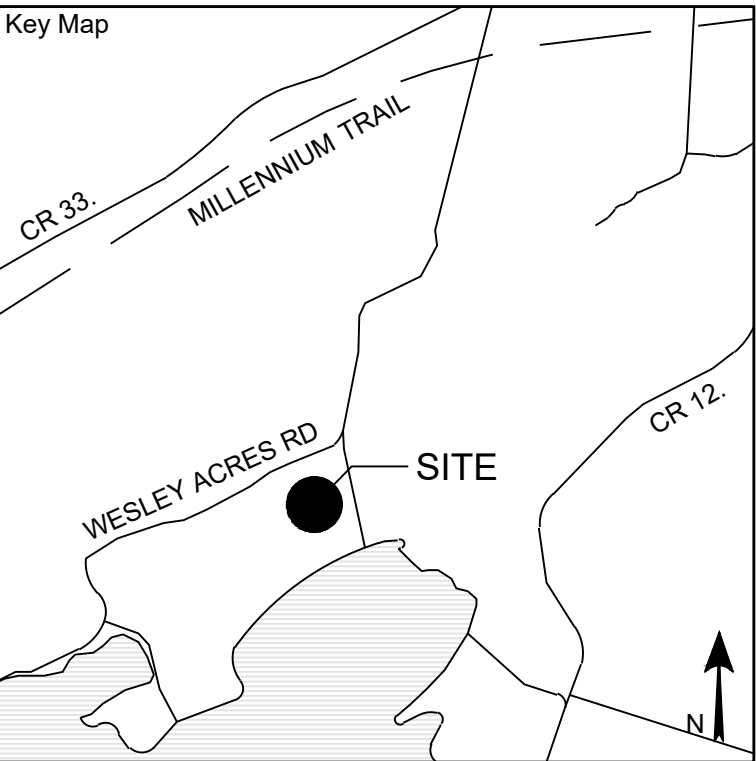

Project Notes
This design and drawing are the property of The Scott Wentworth Landscape Group Ltd. and are not to be copied or used for construction purposes without the Landscape Architect's express written consent.
The contractor shall check and verify all dimensions and report any discrepancies, error, or omissions to the Landscape Architect prior to commencing work.
Base plan information taken from Site Plan provided by:
Company Name:
Dated:

Wentworth Landscapes
13392 Loyalist Parkway R.R.1, Picton ON K0K 2T0
613.547.3772



Consultants




Client CAMPFIRE CIRCLE	Project CAMPFIRE CIRCLE	Project Location 565 WESLEY ACRES ROAD BLOOMFIELD, ON	Drawing Title LANDSCAPE ENLARGEMENT PLAN (3 OF 4)	Scale 1:500	Date 2025-06-25	Plot Date 2026-08-18
					Designed By MH	Drawn By PL/LT
					Approved By SW	Drawing Number
					Project Number 23011-DC	L3.3

G:\Shared drives\Commercial Department\02 - PROJECTS\2023\23011-DC - Campfire Circle - SWSHEET SET\23011-DC - Campfire Circle - L3.4 - Enlargement Plan 4.dwg

- BUFFER/SCREENING PLANTING
- EXISTING VEGETATION
- FIRE ROUTE/MAINTENANCE ROAD
- SMALL-CALIPER WHIP TREE PLANTING
- NATURALIZED SHRUB/PERENNIAL PLANTING BEDS TO SOFTEN ARCHITECTURAL HARD EDGES
- DECIDUOUS TREE PLANTING, TYPICAL
- GROVE OF TREE PLANTING TO FRAME AND ENCLOSE GATHERING AREAS
- 100 YEAR FLOOD ELEVATION
- PROPERTY LINE
- WAVE UPRUSH
- EROSION LIMIT
- WETLAND SETBACK
- 6m SETBACK FROM EROSION HAZARD
- LIGHTING, TYPICAL
REFER TO ELECTRICAL LIGHTING PLAN FOR DETAILS
- WOODEN BOARDWALK PATH
- WASHROOM
- GATHERING AREAS SPACED 100m TO 150m ALONG PATHWAYS
- CAMPSITES, TYPICAL
- ASPHALT WALKING TRAILS
- OFF GRID CABIN
- RIPARIAN ENHANCEMENT ZONE

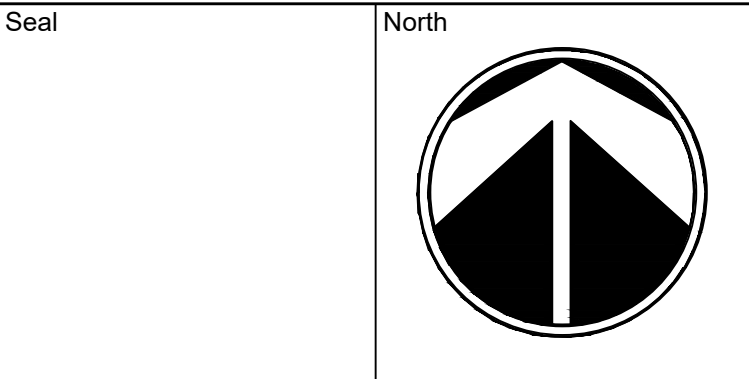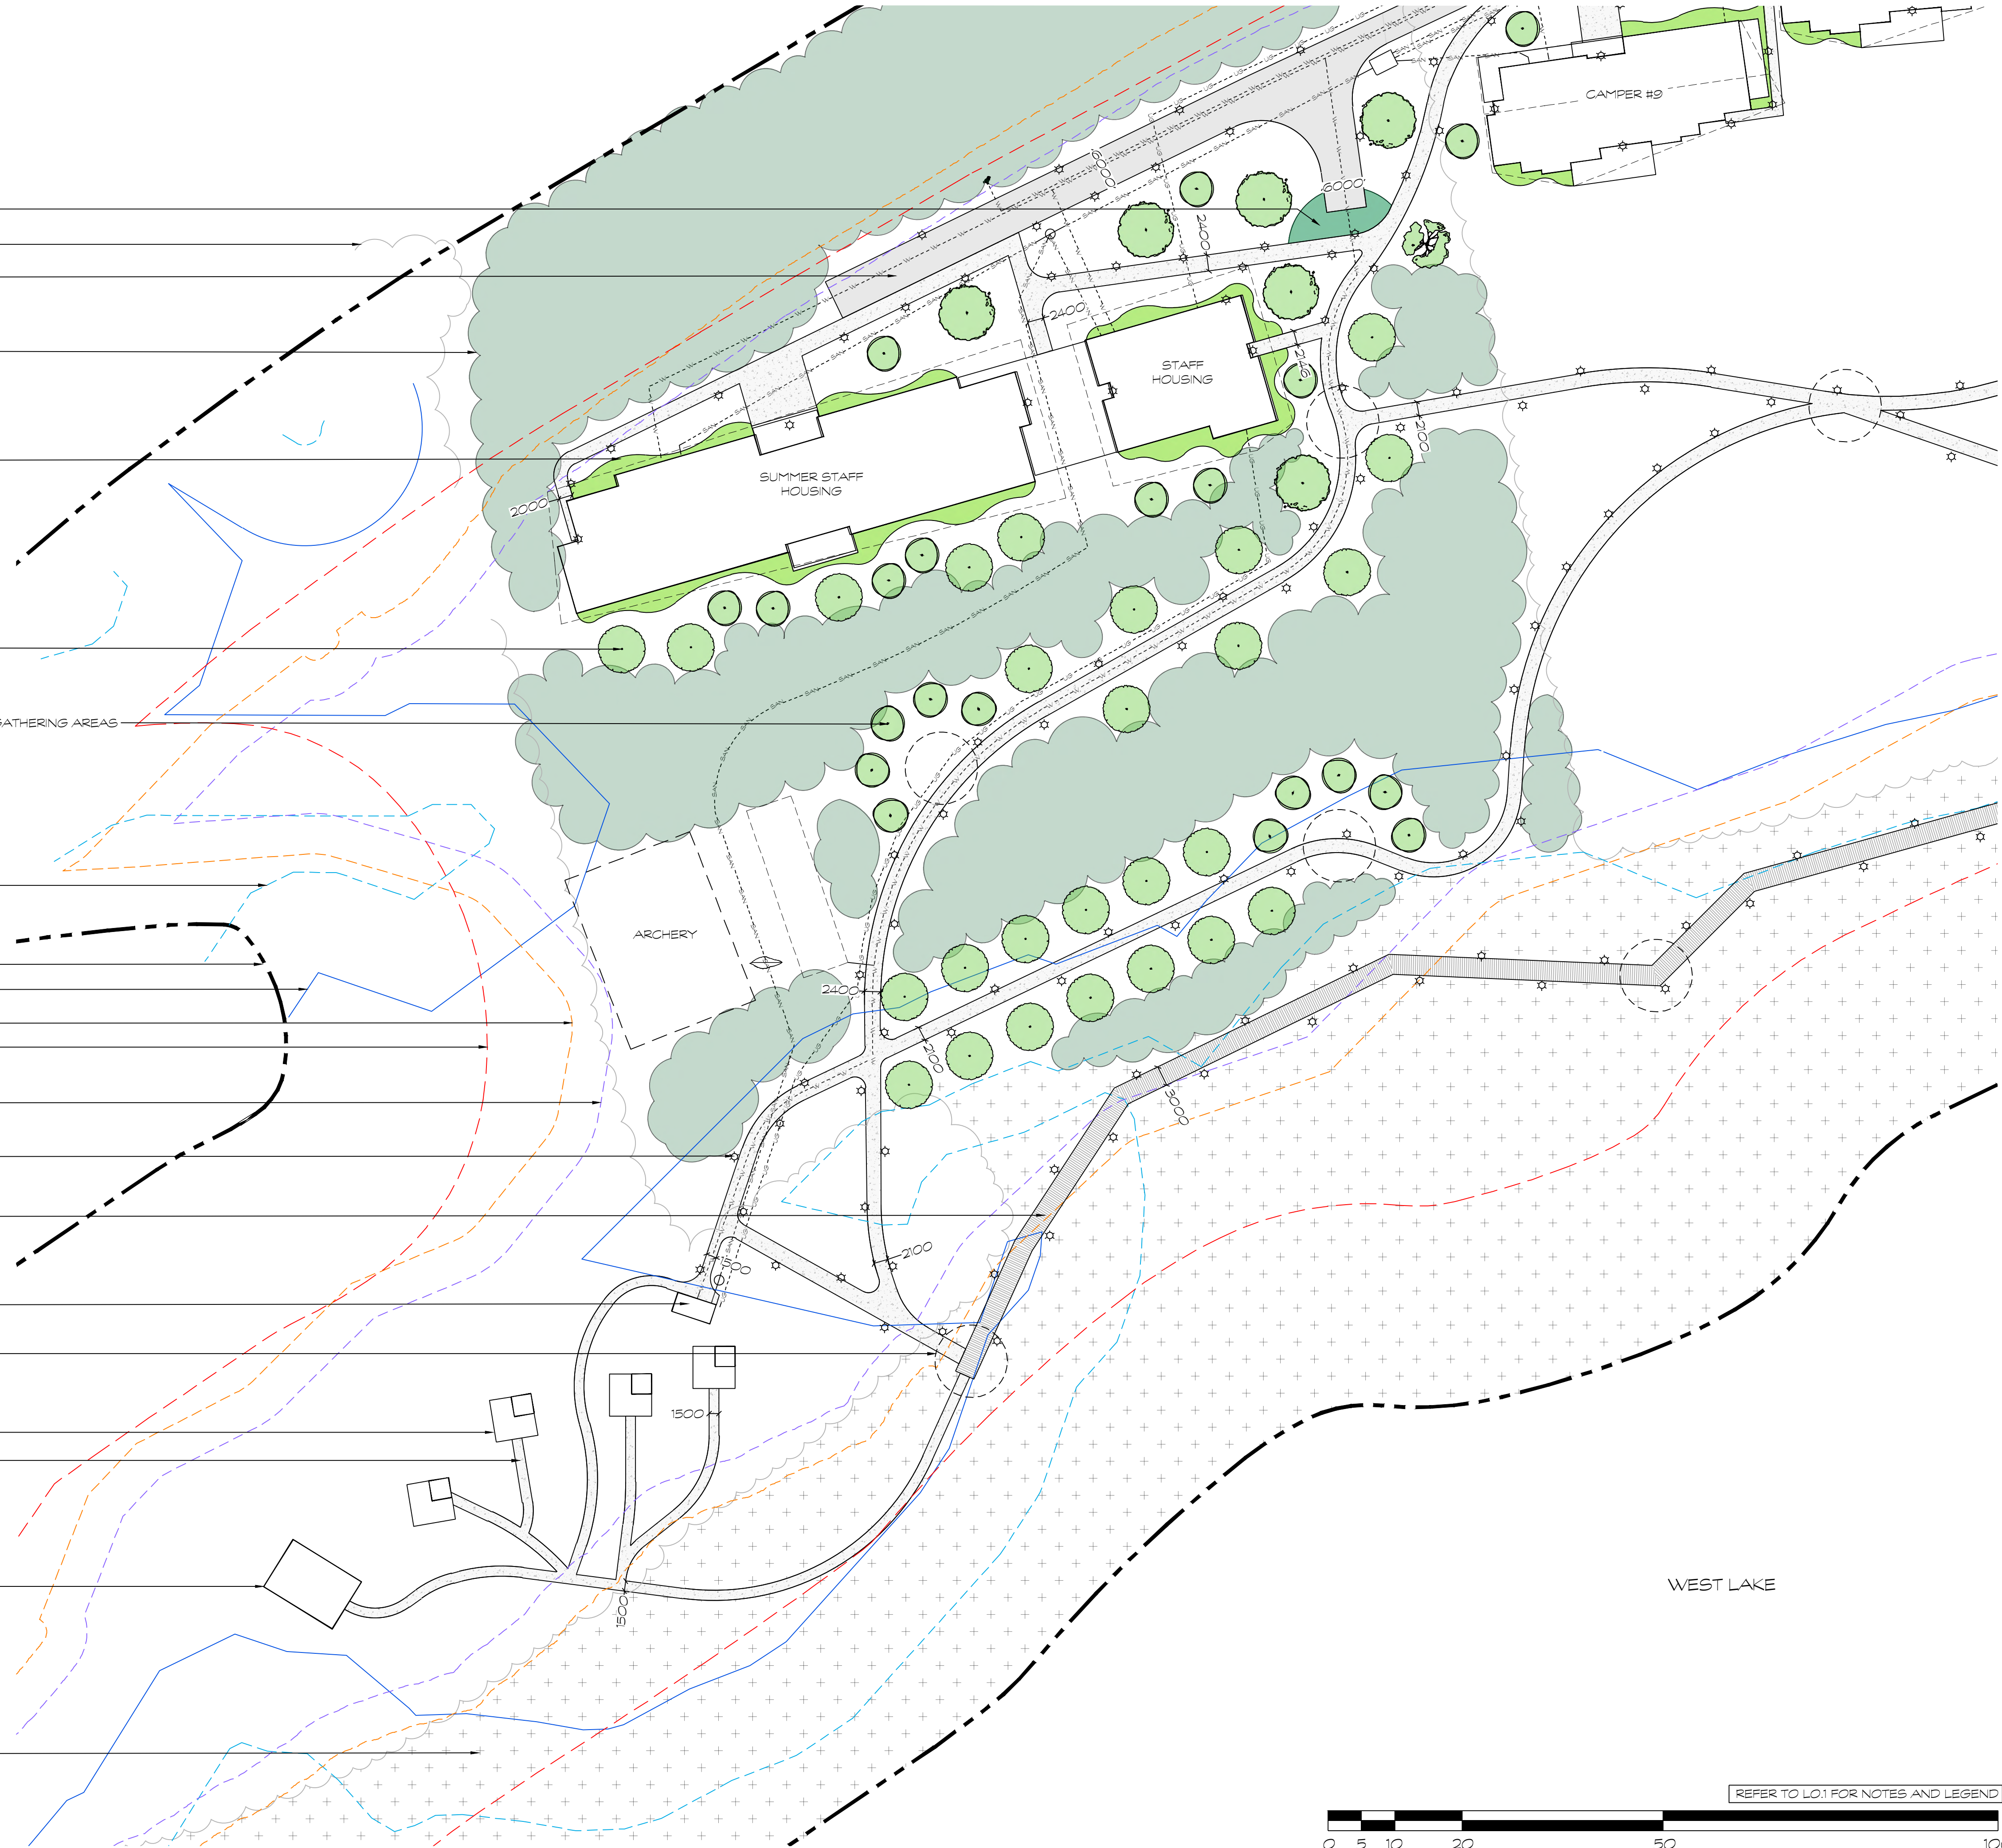

No.	Issues and Revisions	Date
1.	ISSUED FOR SPA	2025-08-15
2.	ISSUED FOR COORDINATION	2026-01-27
3.	REISSUED FOR SPA	2026-02-06
4.	REISSUED FOR COORDINATION	2026-07-28
5.	ISSUED FOR SPA - 3RD SUBMISSION	2026-08-18

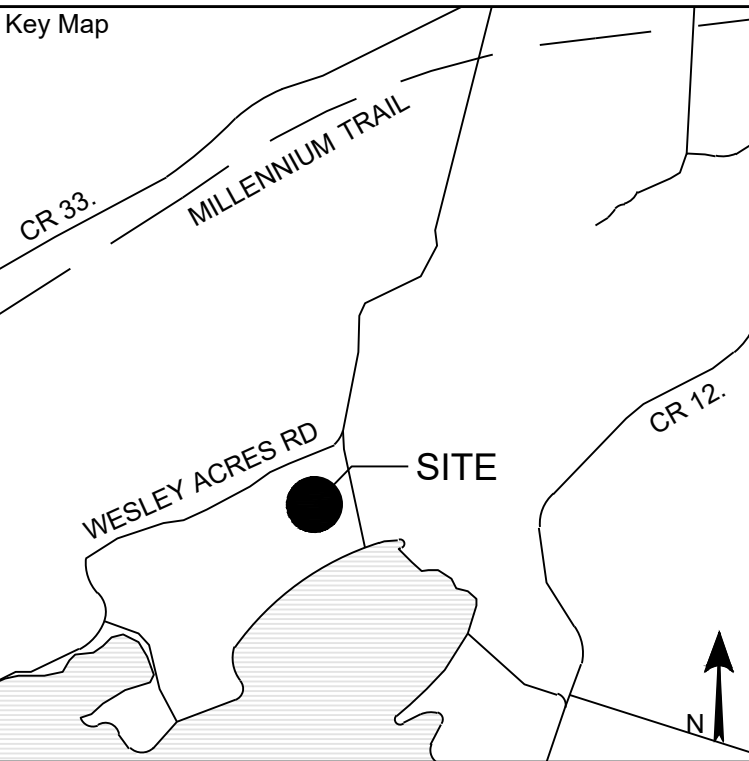

Project Notes
This design and drawing are the property of The Scott Wentworth Landscape Group Ltd. and are not to be copied or used for construction purposes without the Landscape Architect's express written consent.

The contractor shall check and verify all dimensions and report any discrepancies, error, or omissions to the Landscape Architect prior to commencing work.

Base plan information taken from Site Plan provided by:
Company Name:
Dated:

Wentworth Landscapes
13392 Loyalist Parkway R.R.1, Picton ON K0K 2T0
613.547.3772

Consultants



Client CAMPFIRE CIRCLE	
Project CAMPFIRE CIRCLE	
Project Location 565 WESLEY ACRES ROAD BLOOMFIELD, ON	
Drawing Title LANDSCAPE ENLARGEMENT PLAN (4 OF 4)	
Scale 1:500	
Date 2025-06-25	Plot Date 2026-08-18
Designed By MH	Drawn By PL/LT
Approved By SW	Drawing Number
Project Number 23011-DC	L3.4